

**ST. LOUIS COUNTY JUVENILE CENTER FACILITY**  
 CLAYTON MISSOURI  
 DEPARTMENT OF PUBLIC WORKS  
 DIRECTOR DAVID E. MURRAY
























ARCHITECTS & ENGINEERS  
 CASES ASSOCIATES, INC.  
 CONSULTING ENGINEER  
 ROBERT F. BRUNS  
 MECHANICAL ENGINEER  
 CRAWFORD & WITTE, INC.






DRAWING NO. **S5**  
 PROJECT NO. 0012  
 SHEET NO. 22  
 CHECKED BY: [Signature]

**LEVEL 2 FRAMING**

DATE: 10-1-68

**LEVEL TWO FRAMING PLAN**  
 SCALE 1/8"=1'-0"  
 TOP OF SLAB, EL. 549'-6"

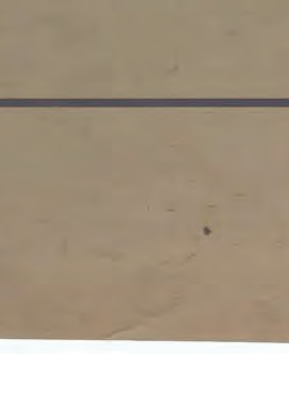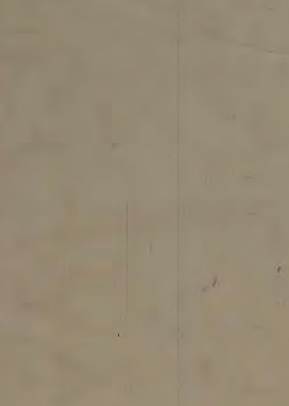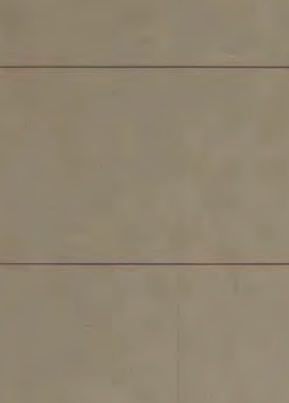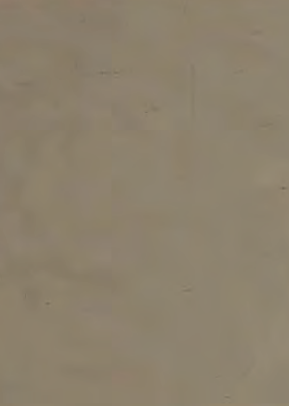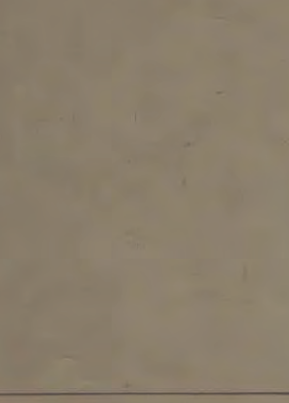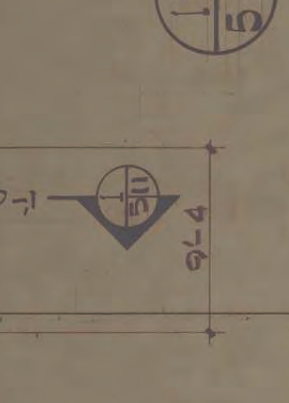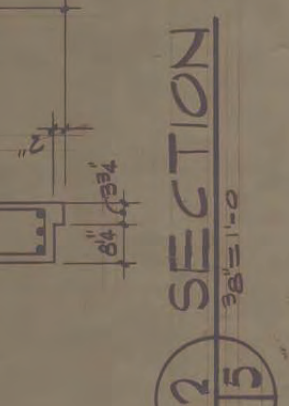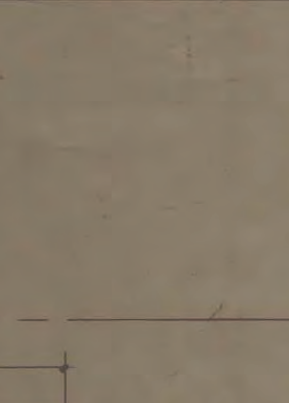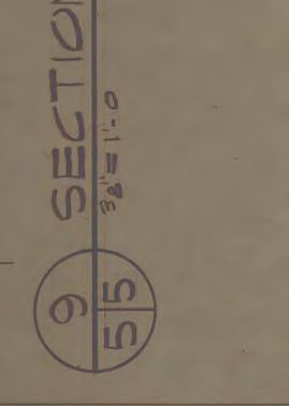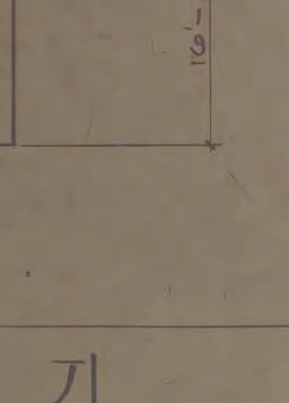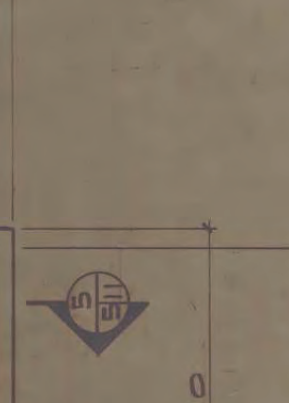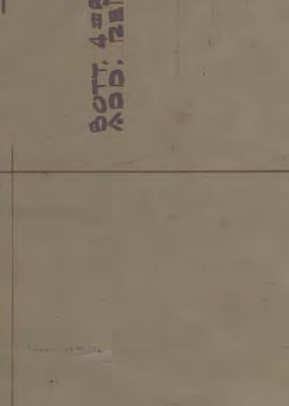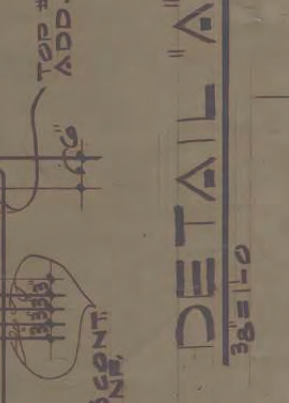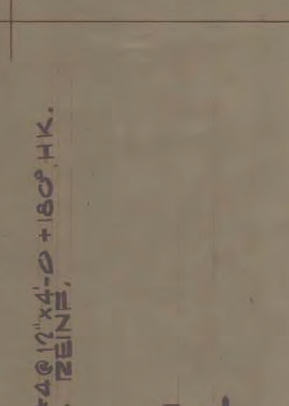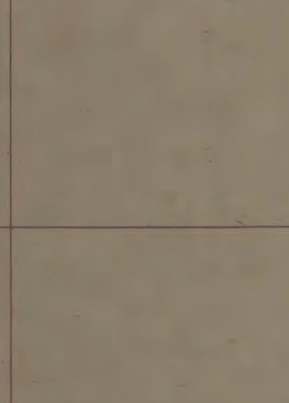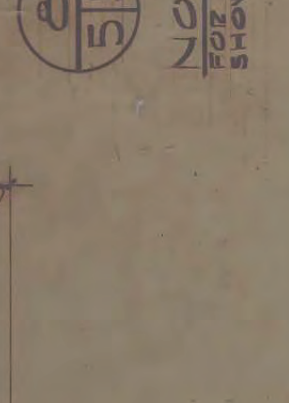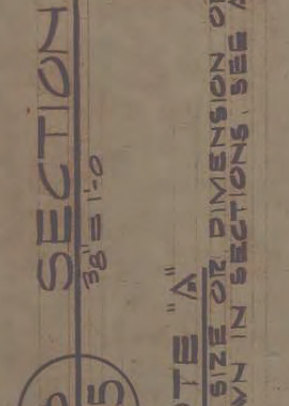
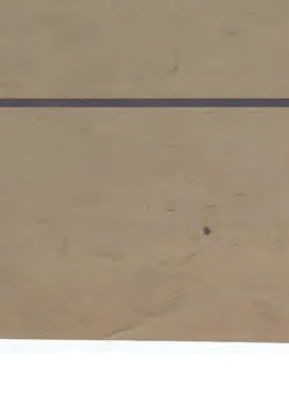
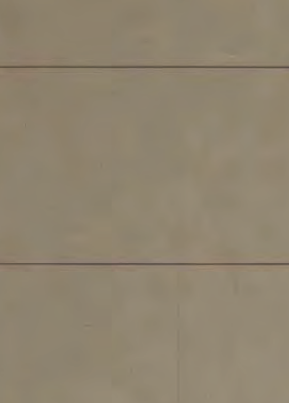
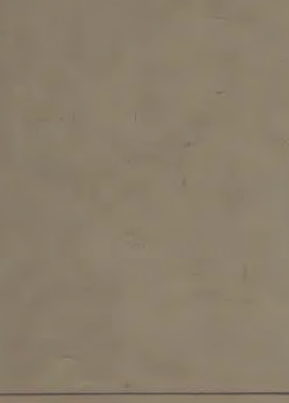
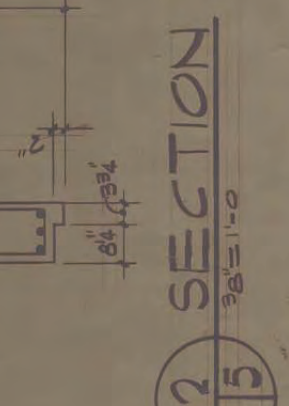
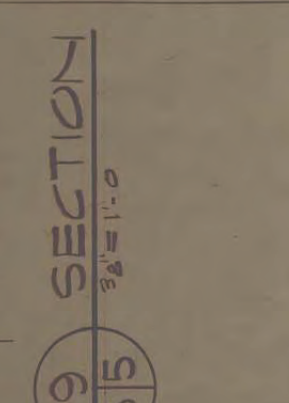
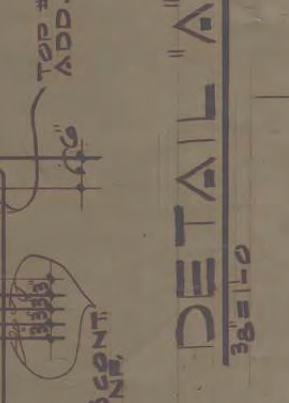


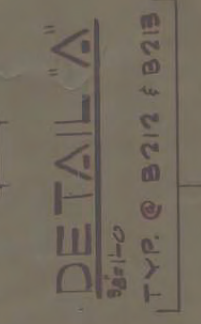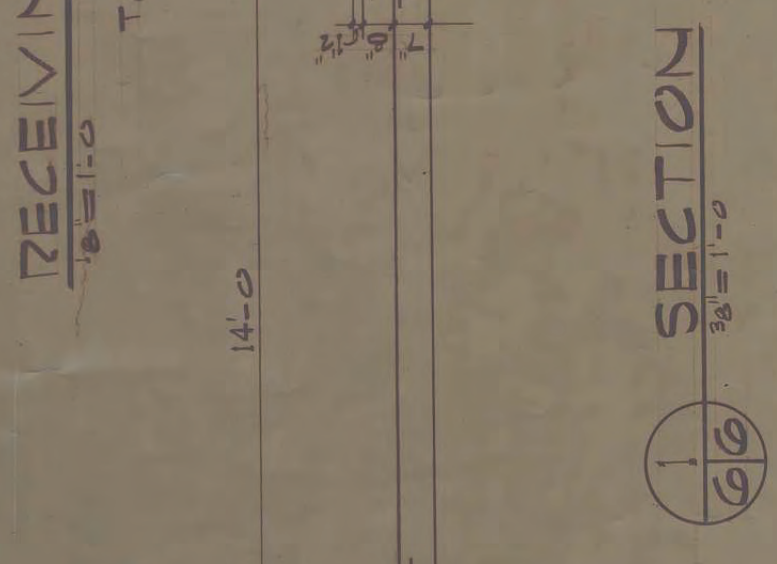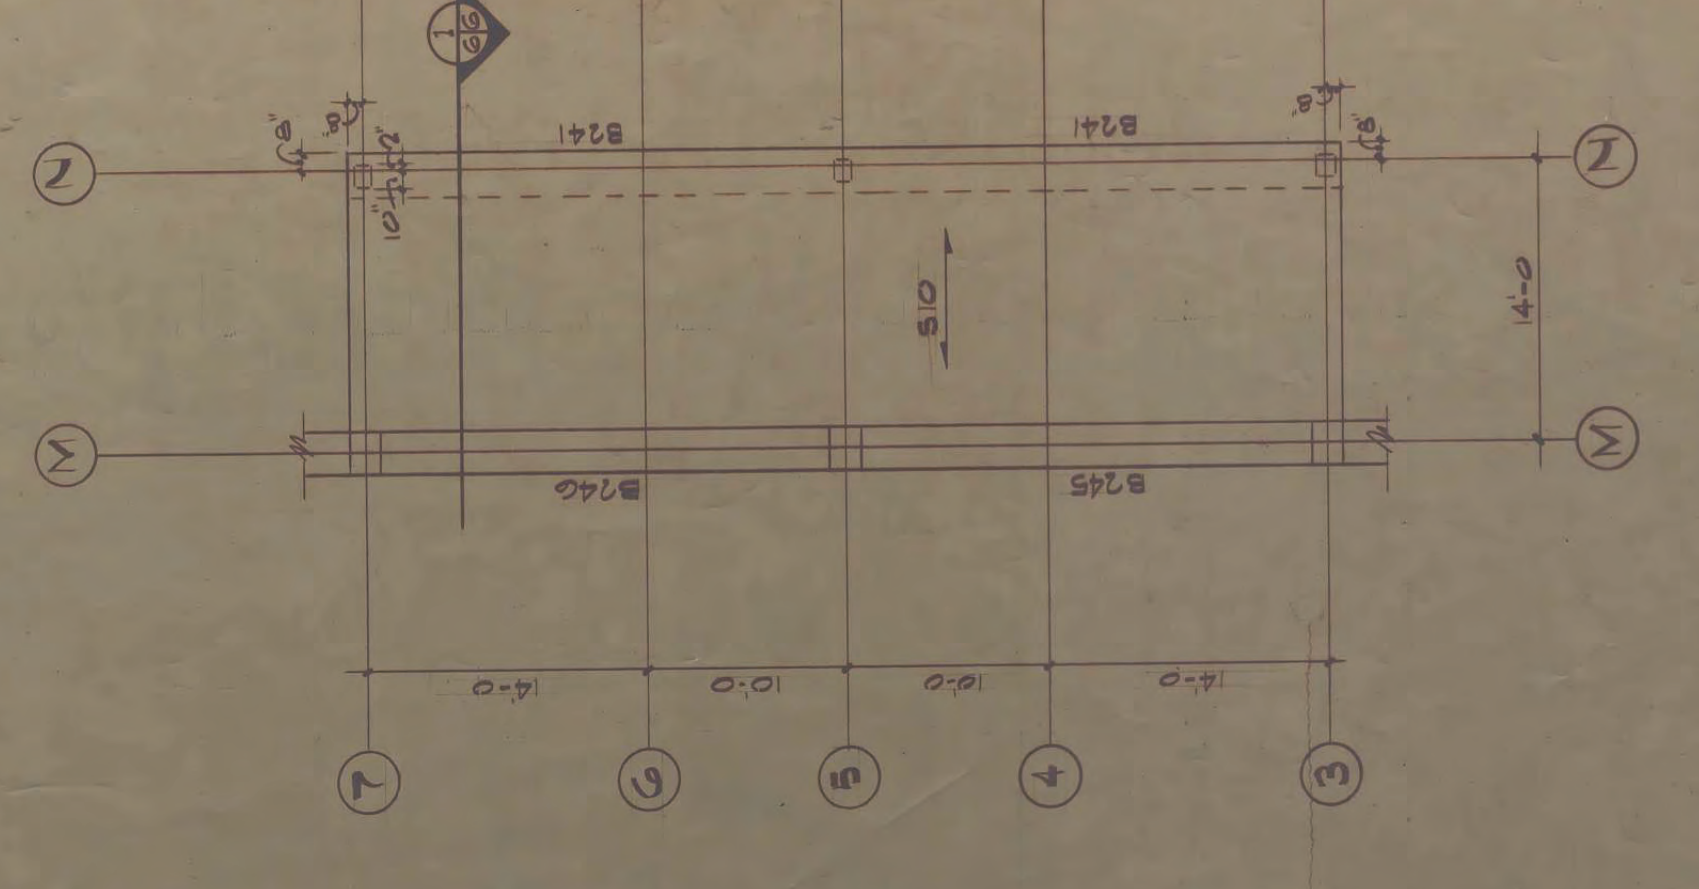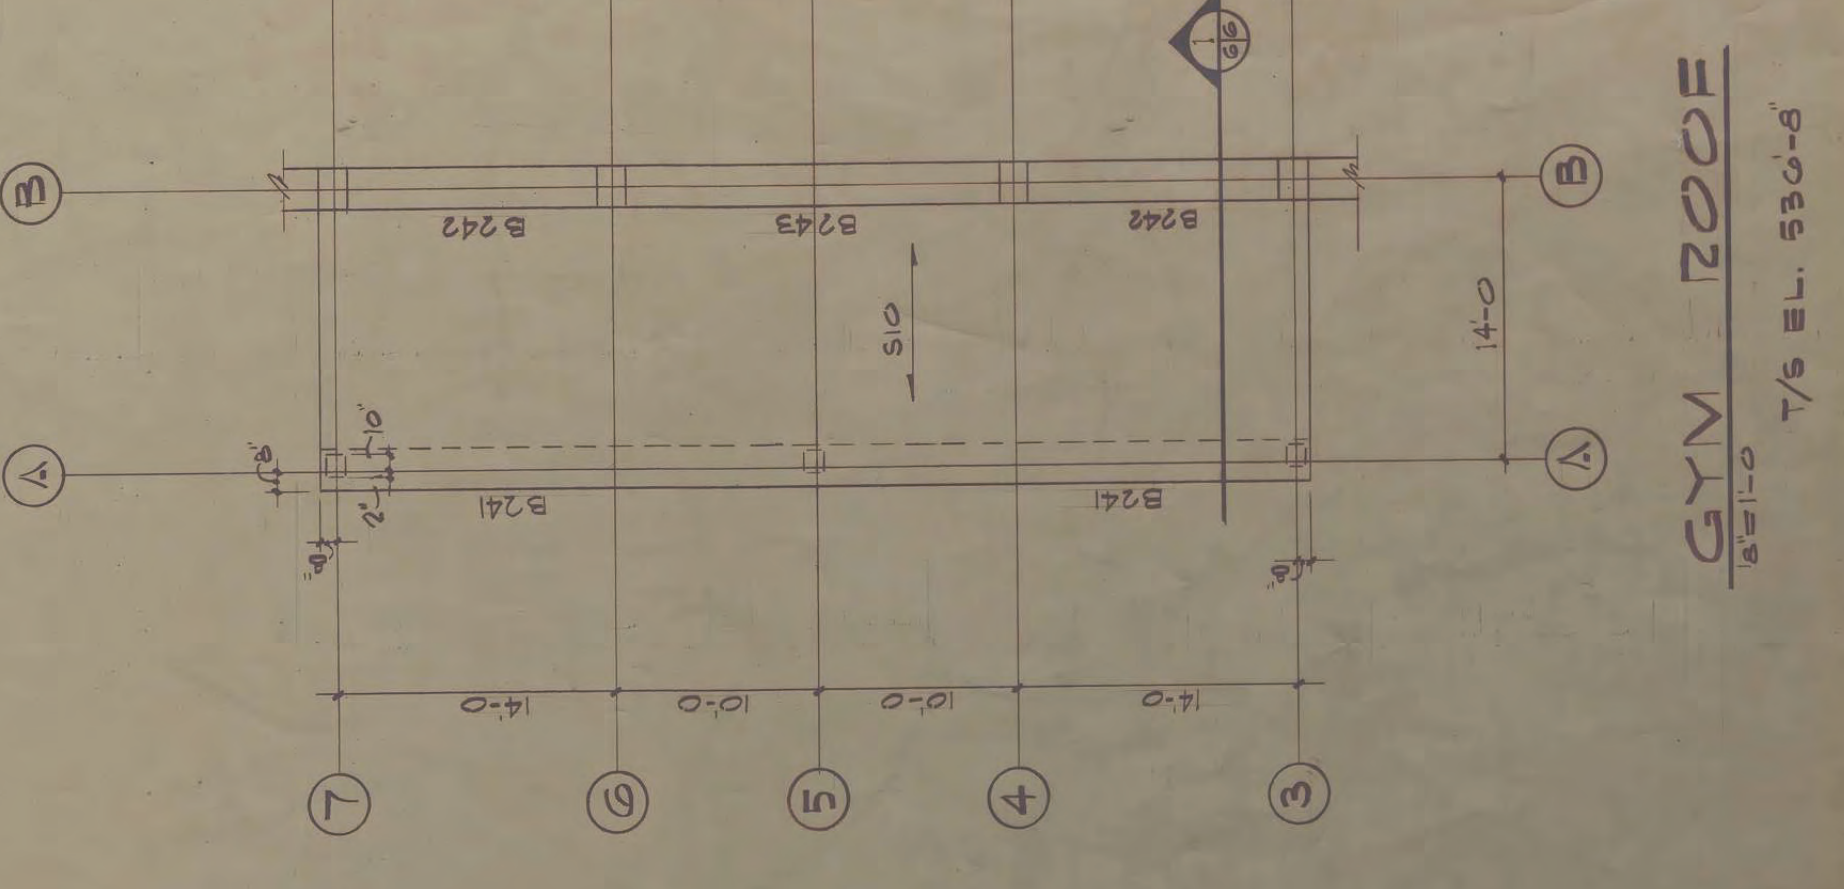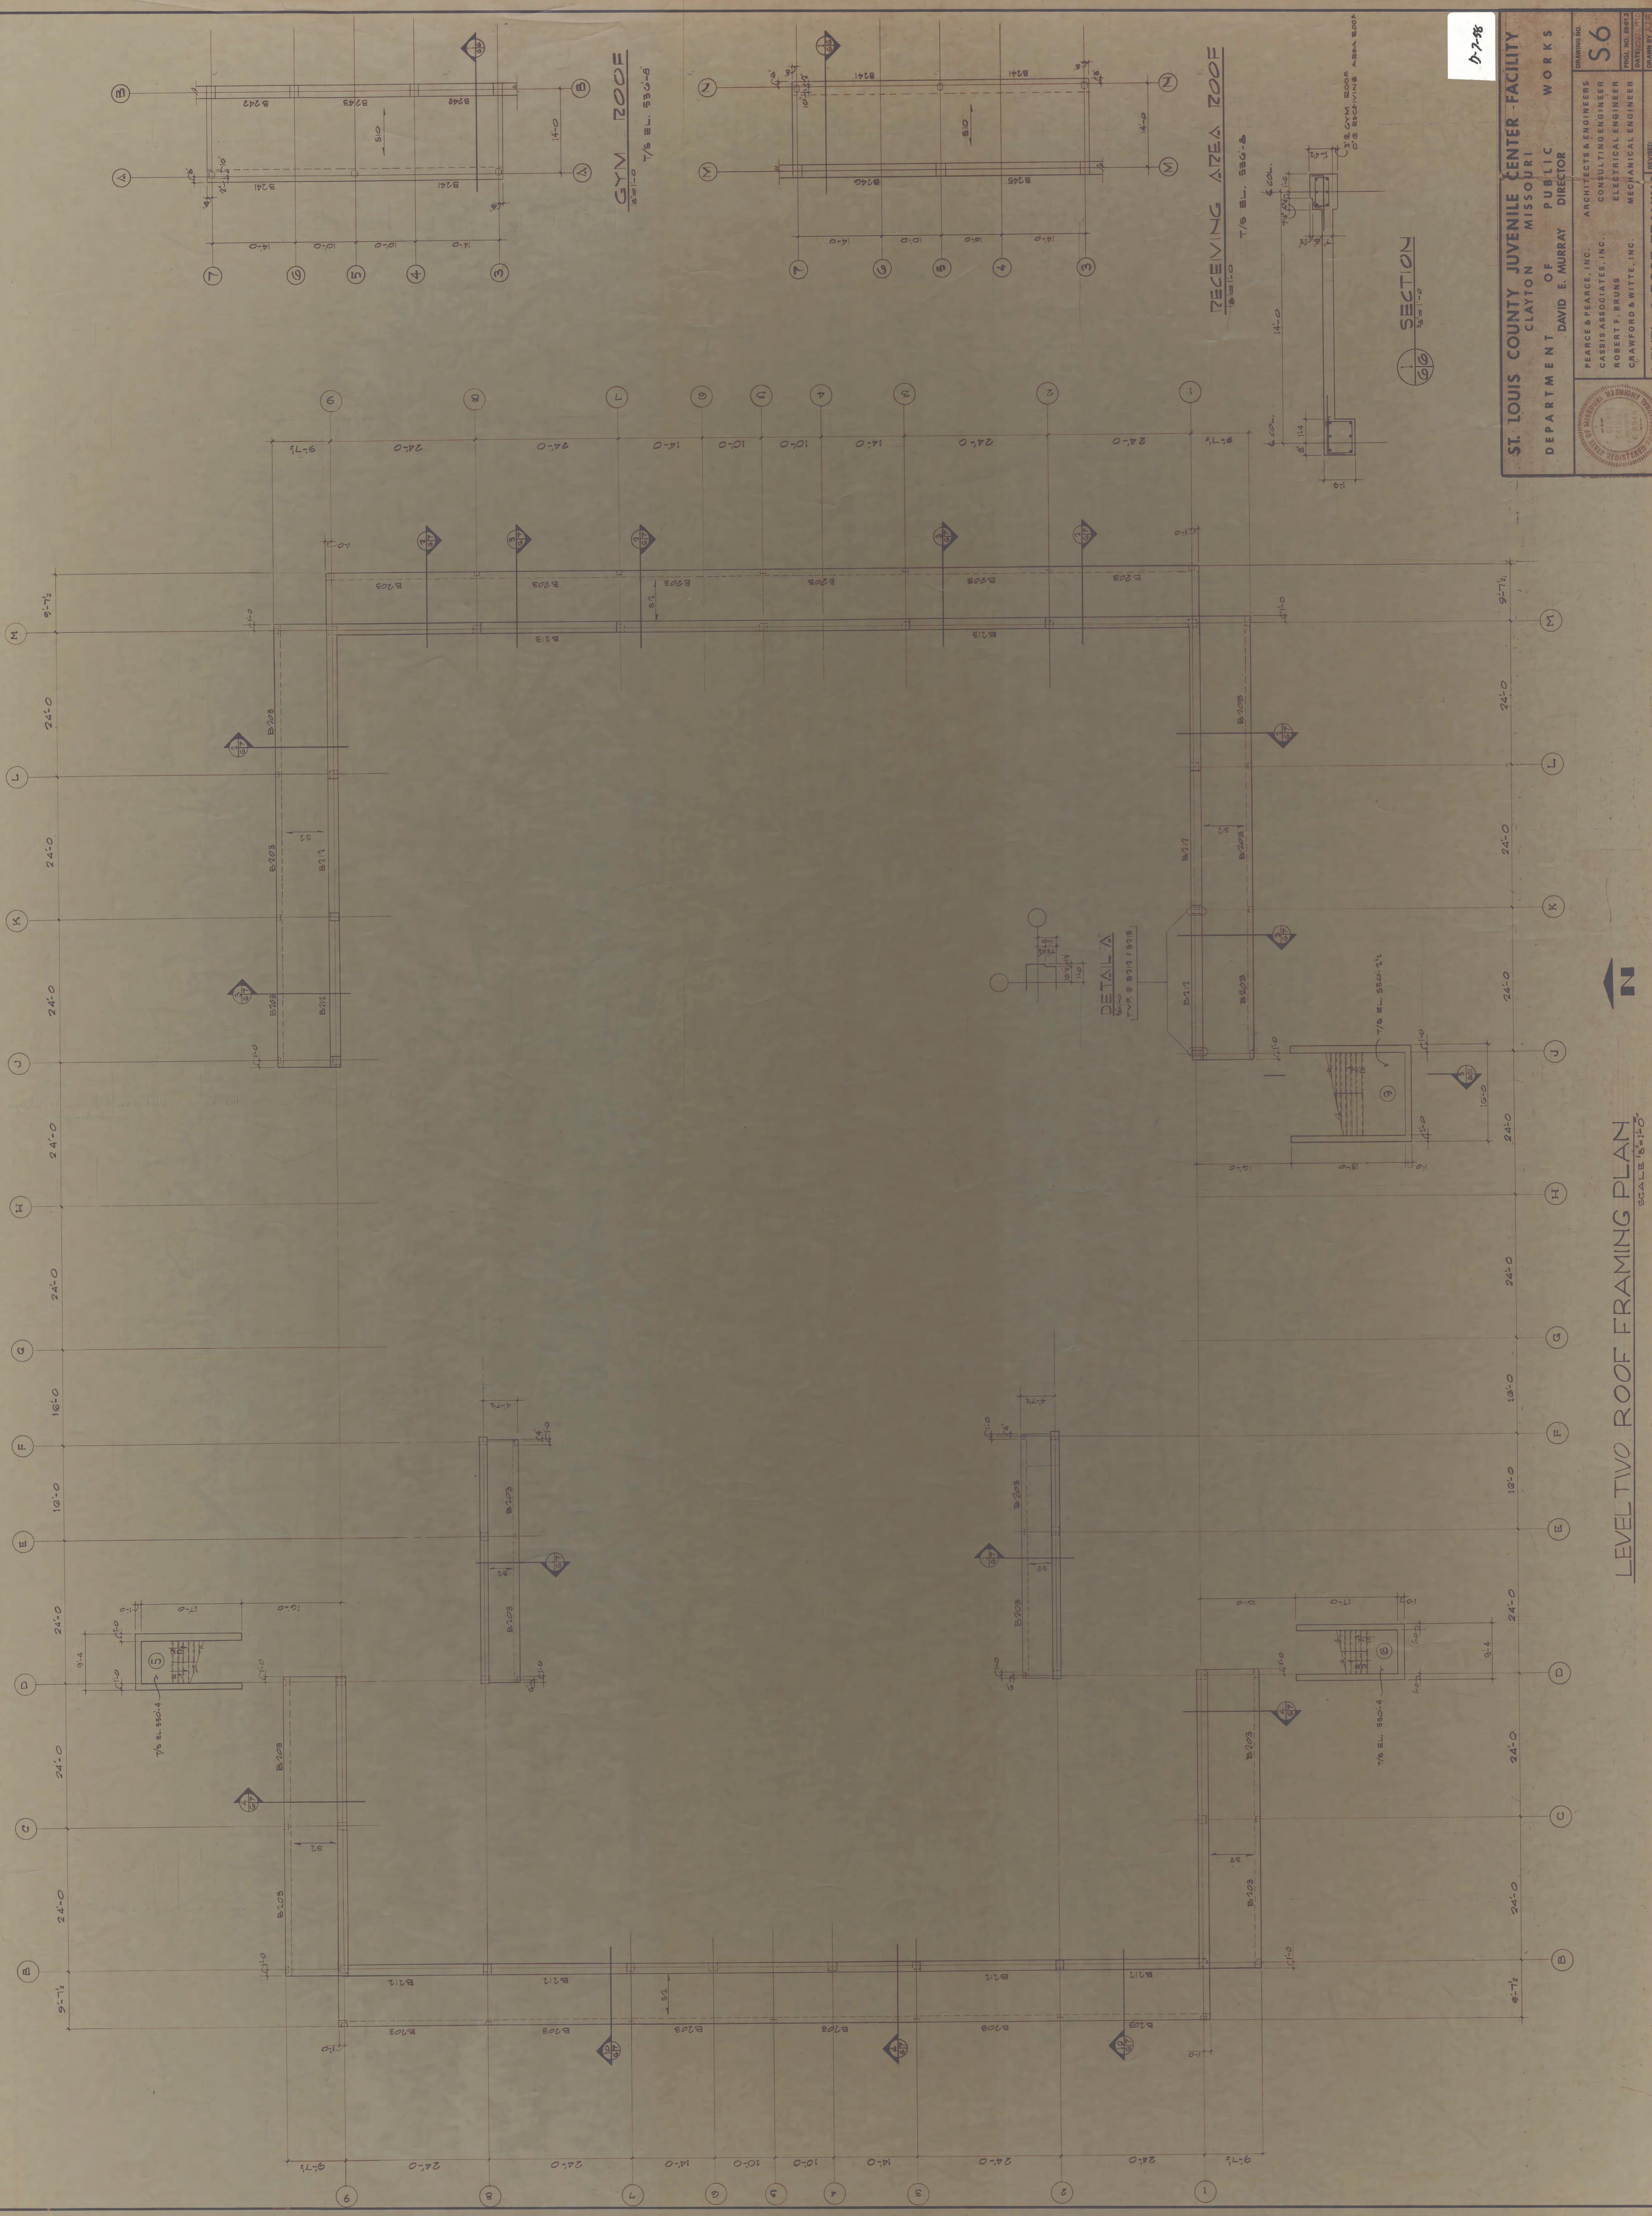

07-88

<b>ST. LOUIS COUNTY JUVENILE CENTER - FACILITY</b>	
CLAYTON MISSOURI	
DEPARTMENT OF PUBLIC WORKS	
DIRECTOR DAVID E. MURRAY	
	ARCHITECTS & ENGINEERS CASBIS ASSOCIATES, INC. CONSULTING ENGINEER ROBERT F. BRUNS ELECTRICAL ENGINEER CRAWFORD & WITTE, INC. MECHANICAL ENGINEER
<b>LEVEL 2 ROOF FRAMING</b>	
DRAWING NO. <b>S6</b>	PREPARED BY: [Name] CHECKED BY: [Name] DATE: [Date]

**LEVEL TWO ROOF FRAMING PLAN**  
SCALE 1/8"=1'-0"  
TOP OF SLAB EL. 552'-0"

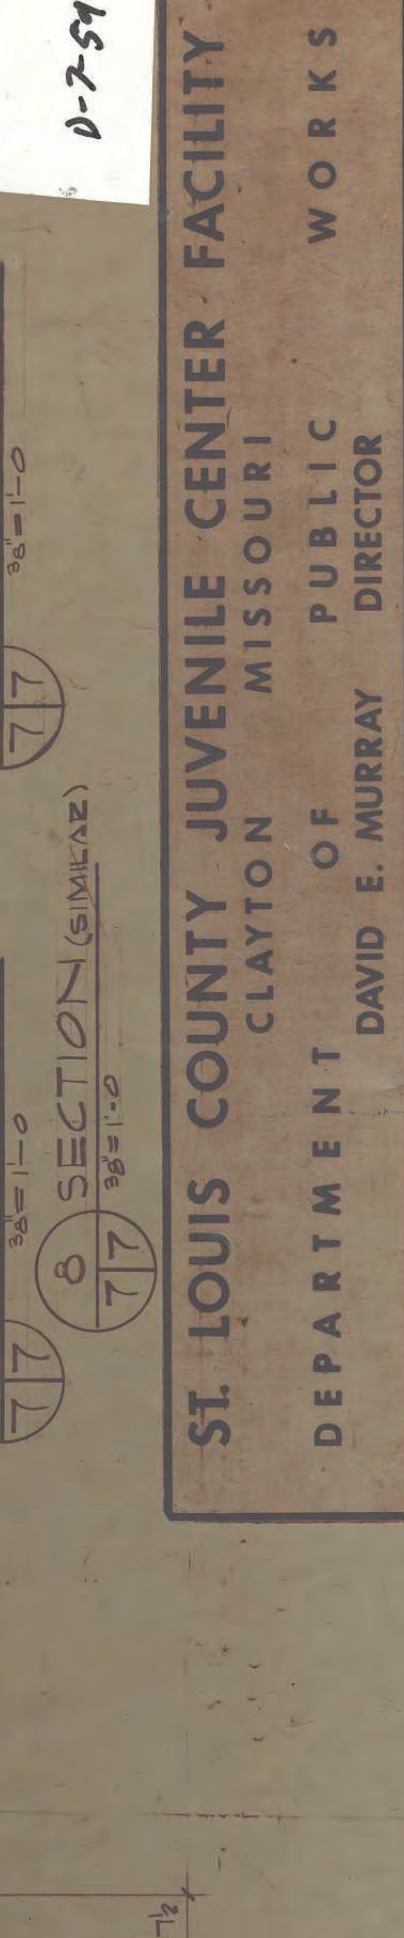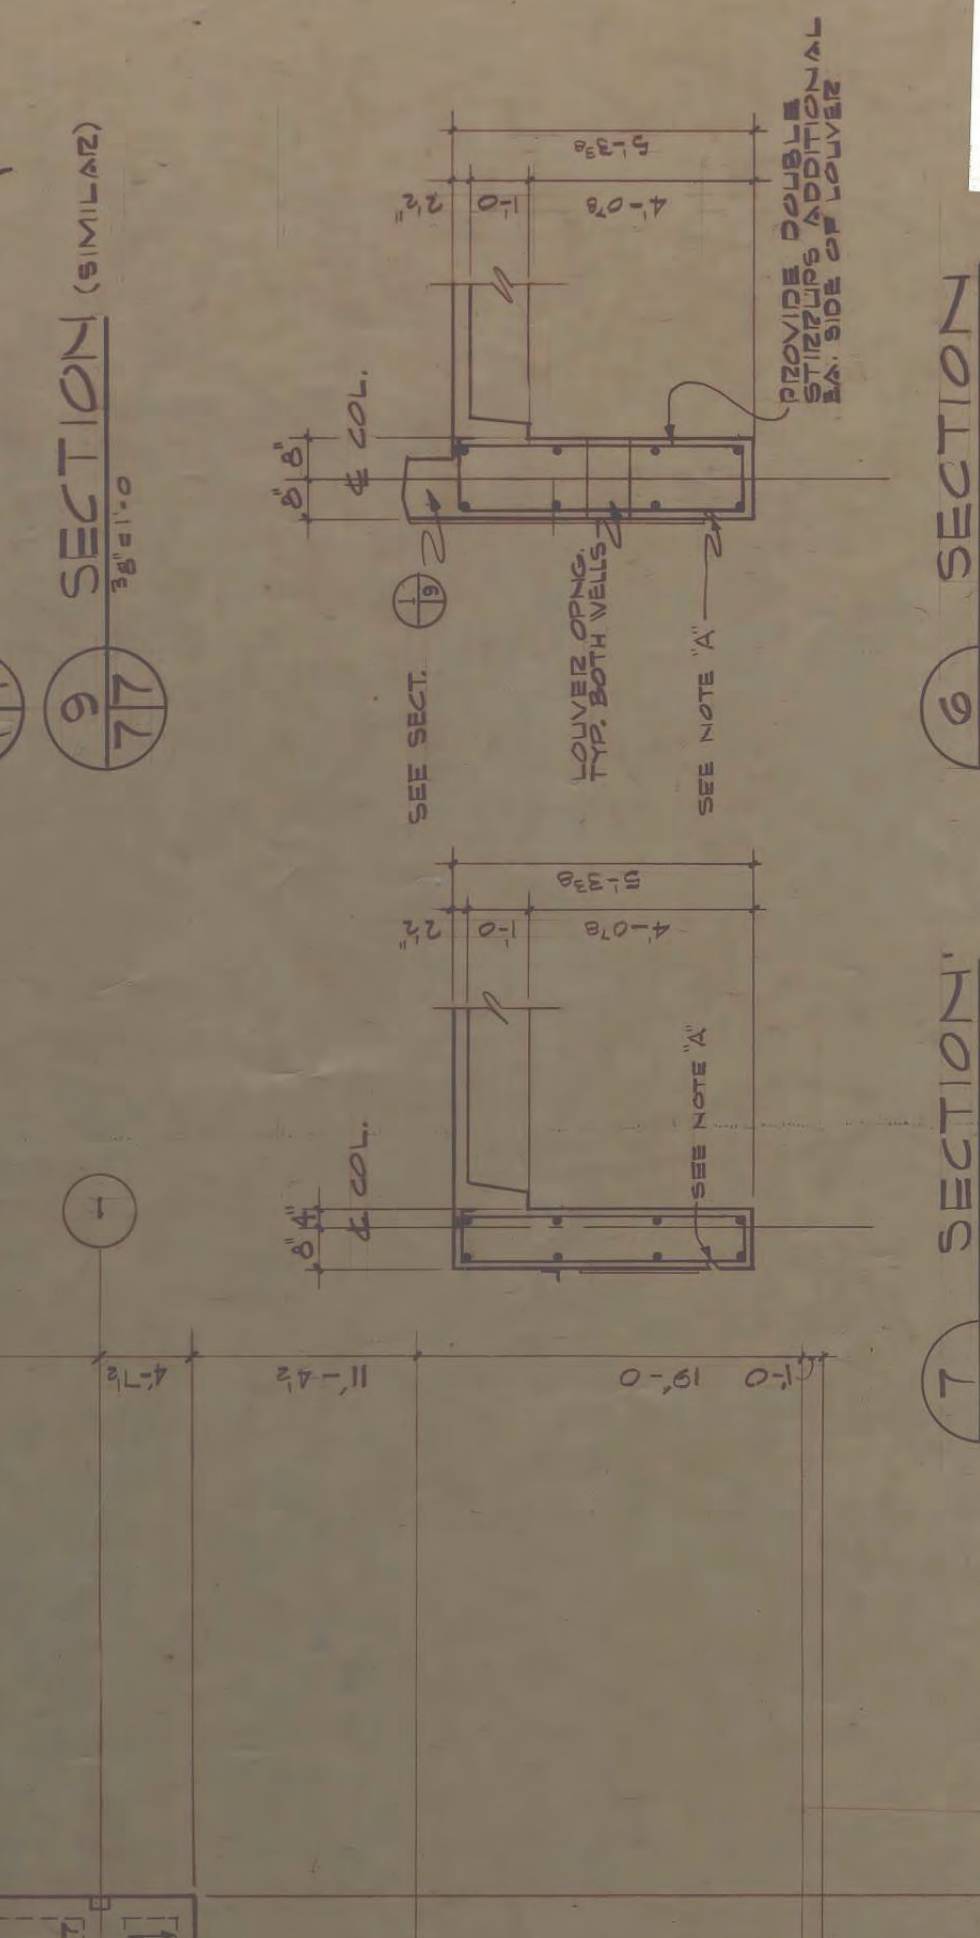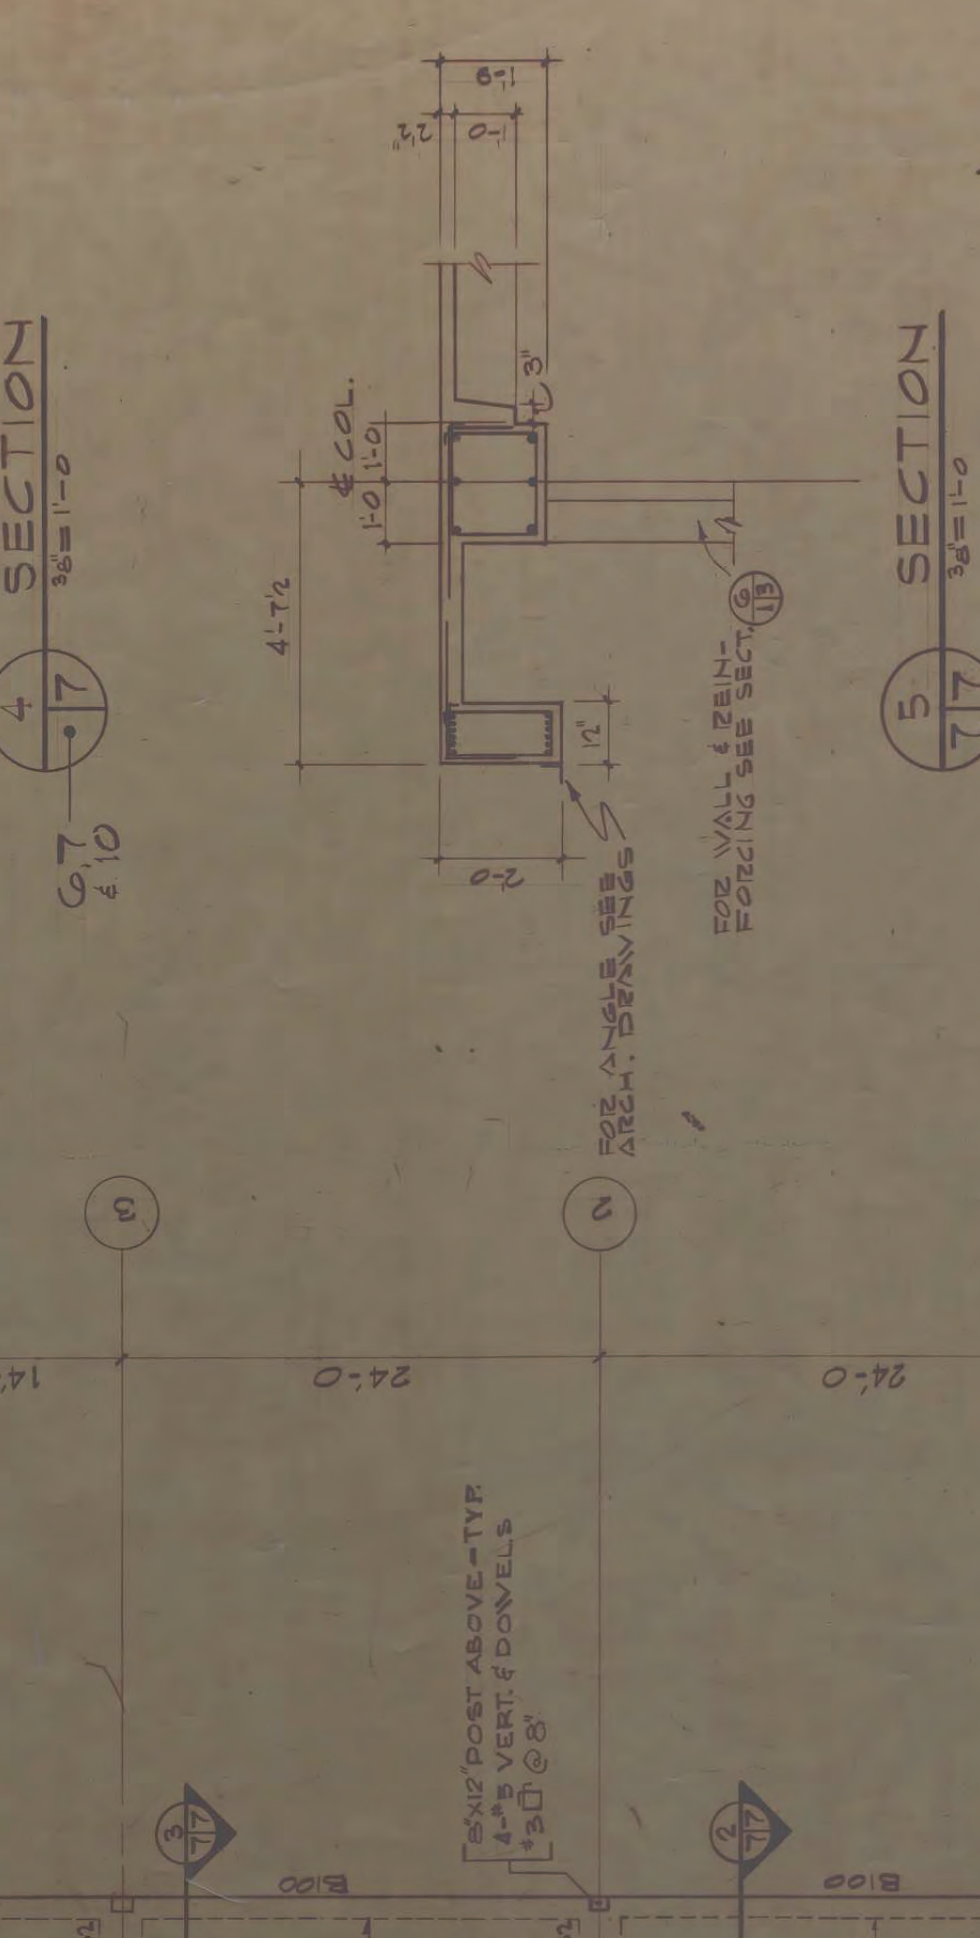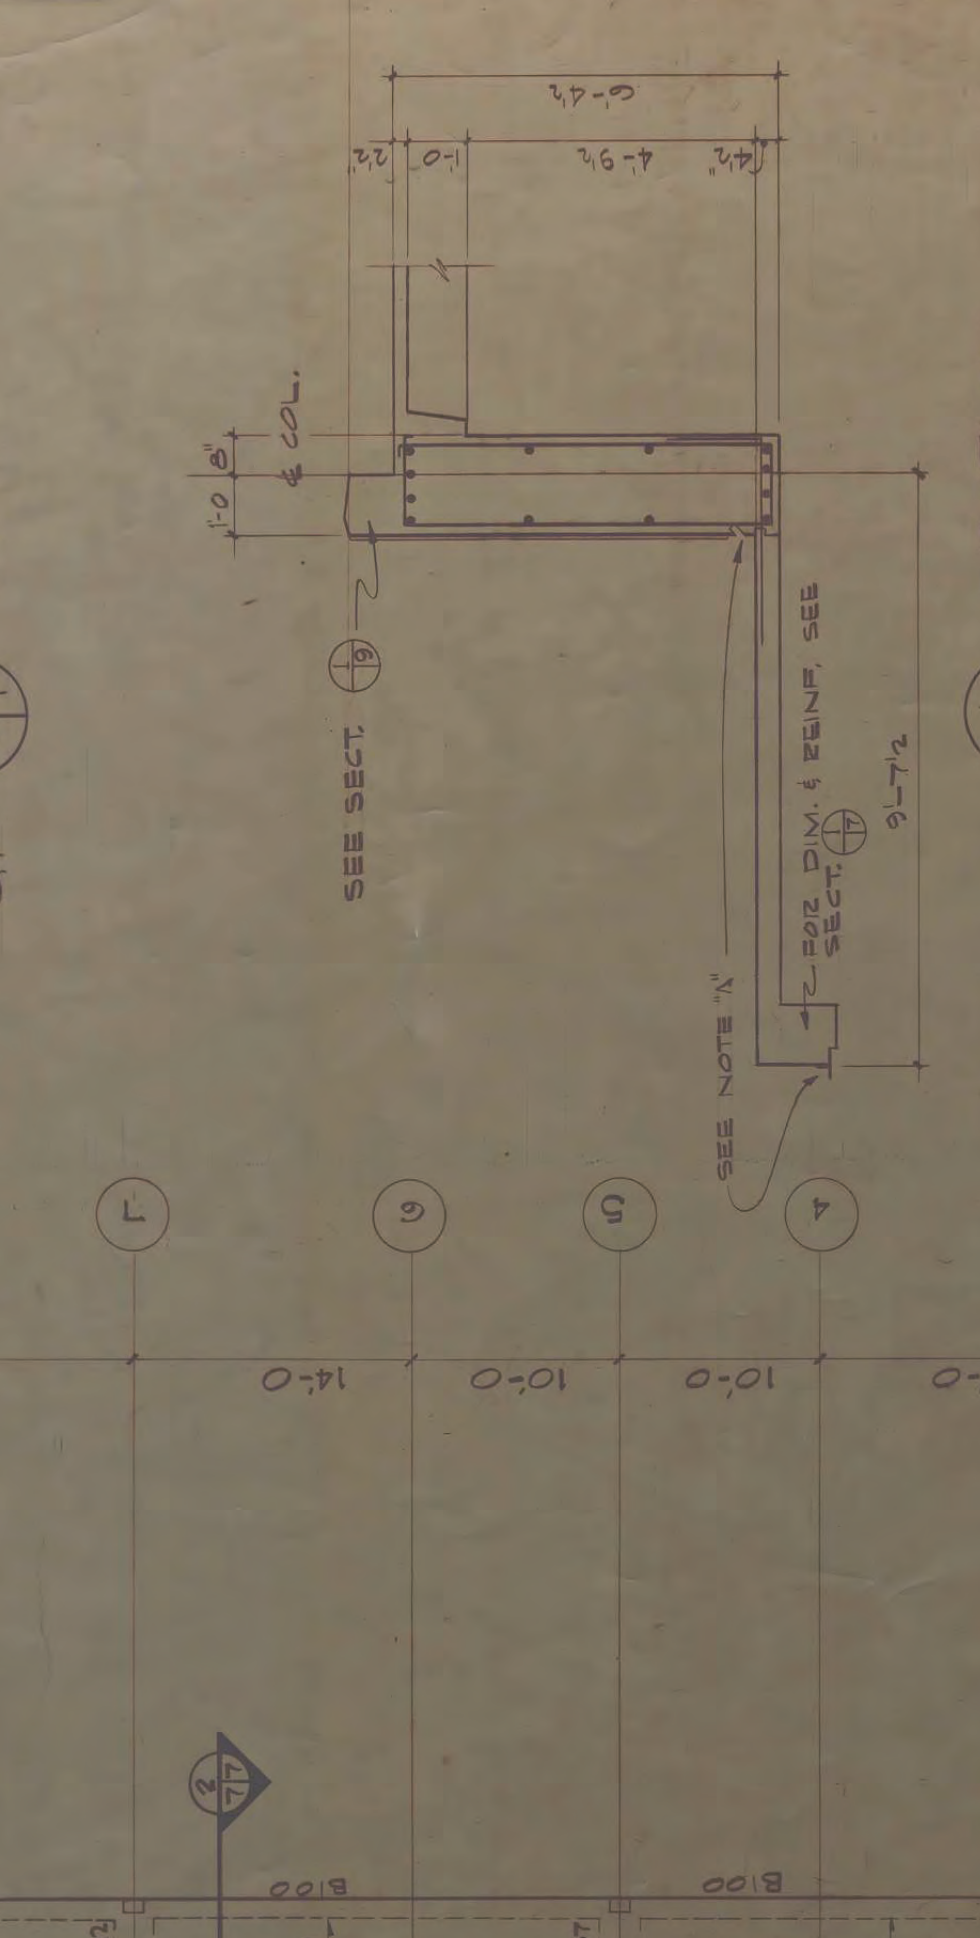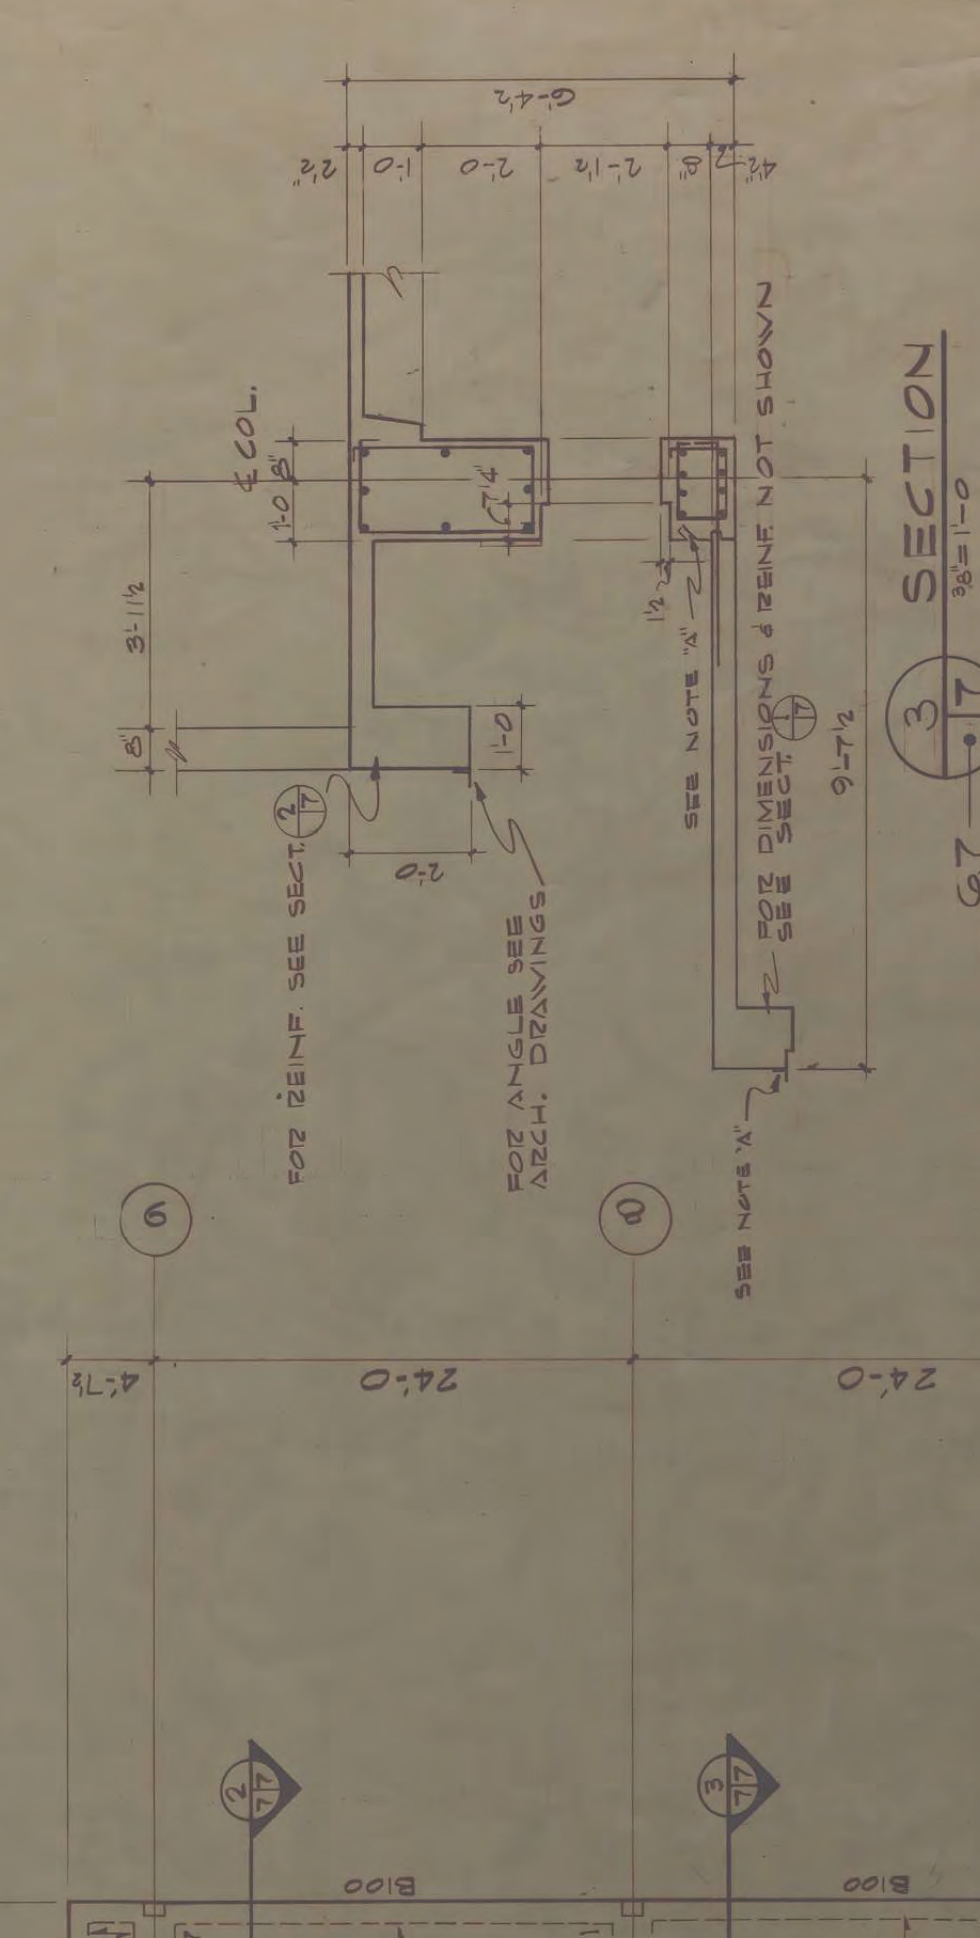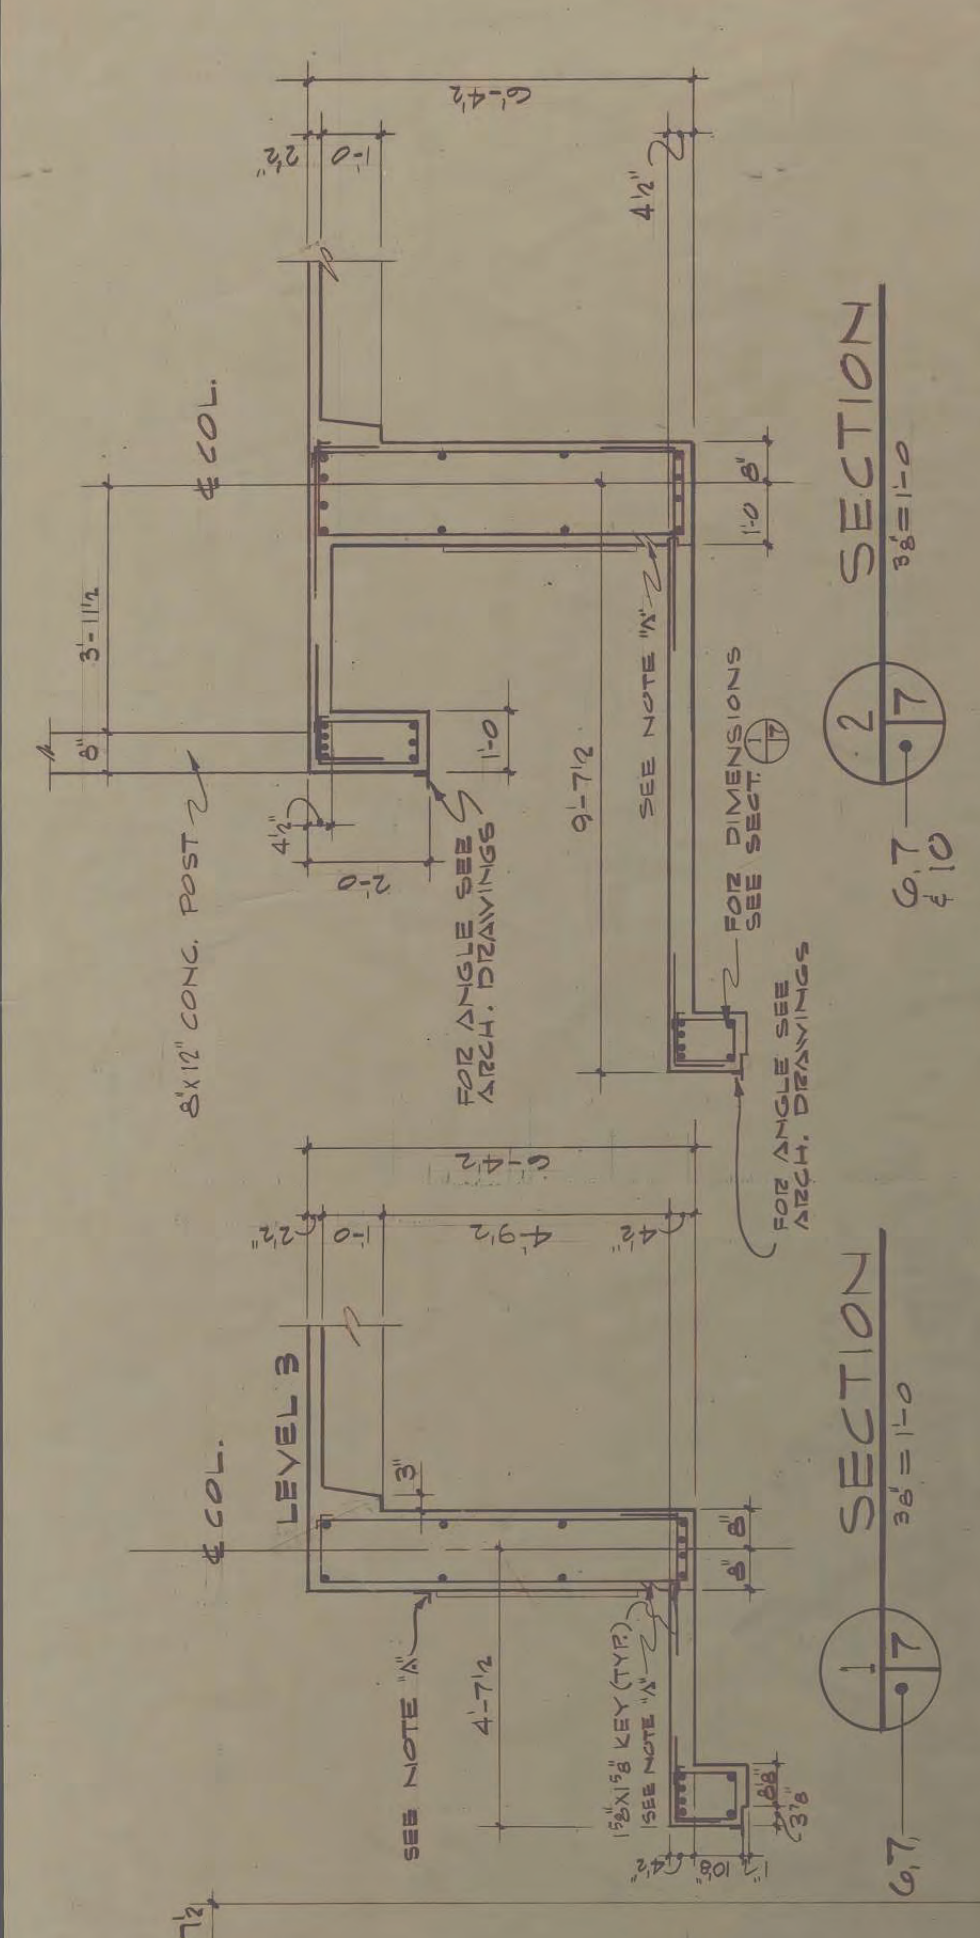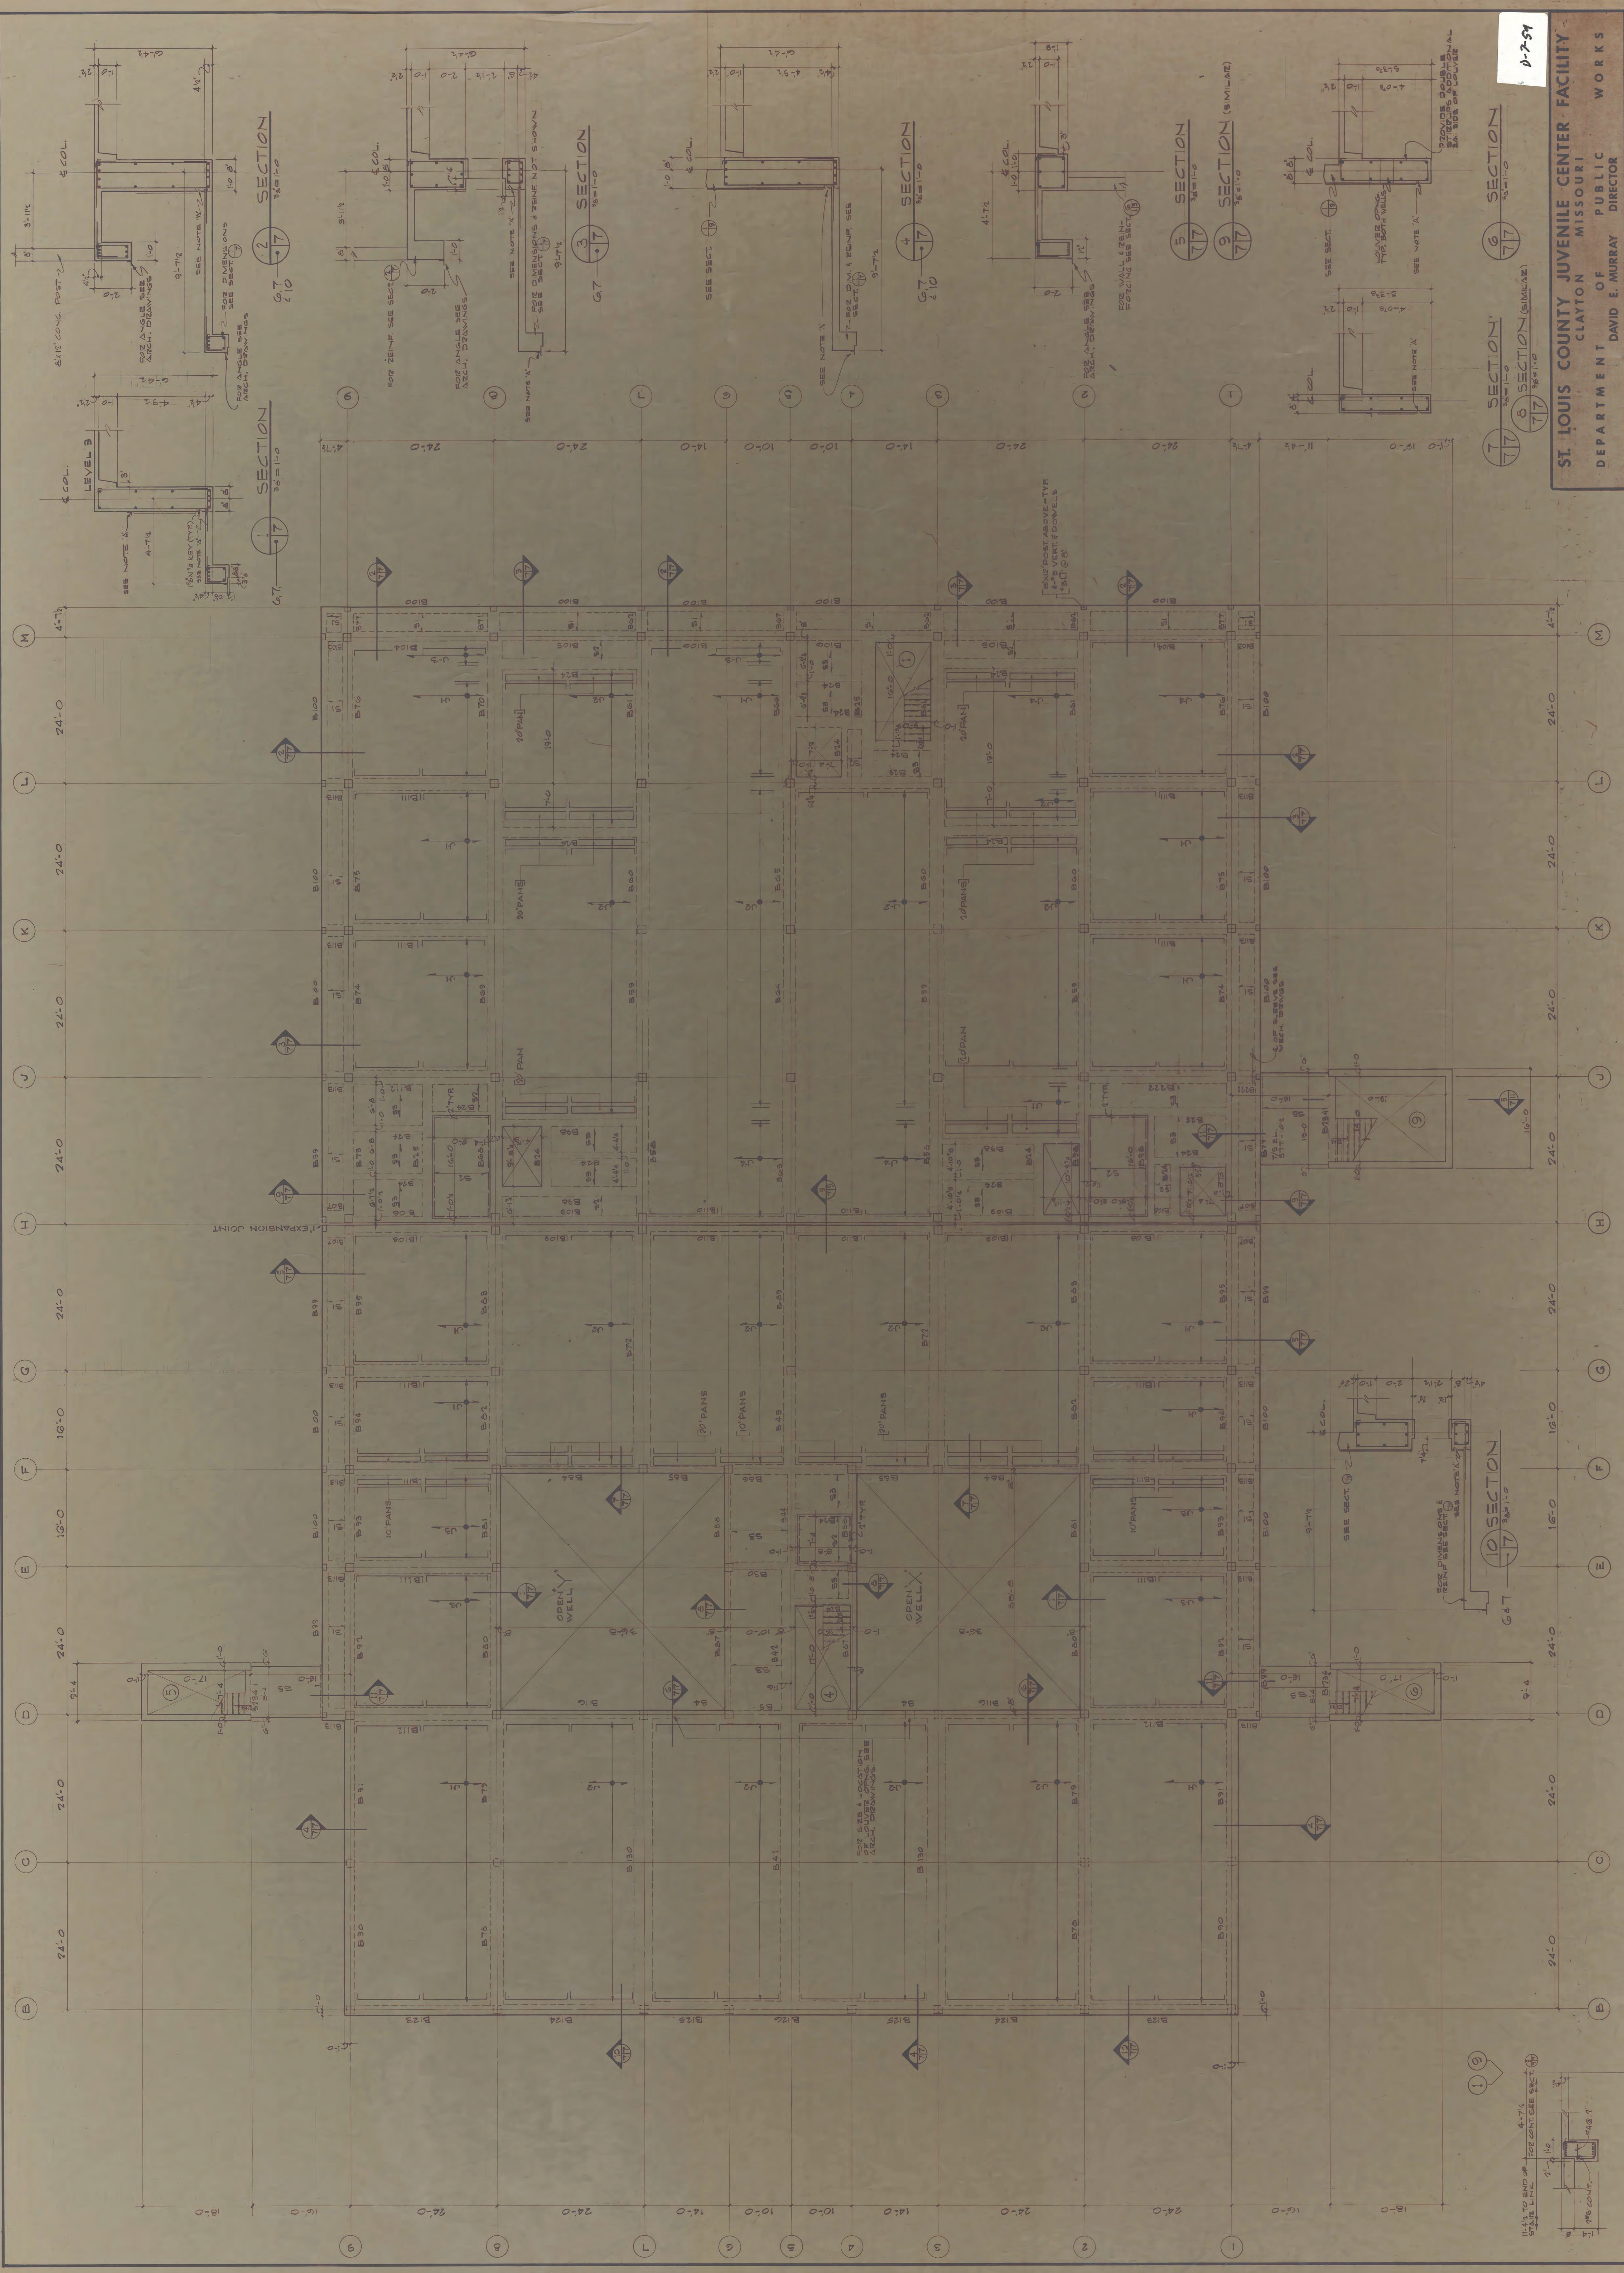

**ST. LOUIS COUNTY JUVENILE CENTER FACILITY**  
 CLAYTON MISSOURI  
 DEPARTMENT OF PUBLIC WORKS  
 DIRECTOR DAVID E. MURRAY

ARCHITECTS & ENGINEERS  
 PEABODY & PERCE, INC.  
 CONSULTING ENGINEER  
 ROBERT F. BRUNS  
 ELECTRICAL ENGINEER  
 CRAWFORD & WITTE, INC.  
 MECHANICAL ENGINEER


DRAWING NO. S7  
 DATE: 10/1/77  
 DRAWN BY: J.E.  
 CHECKED BY: J.E.

**LEVEL 3 FRAMING**

**LEVEL THREE FRAMING PLAN**  
 SCALE: 1/8" = 1'-0"  
 TOP OF SLAB: 55'-0" UNLESS NOTED

**SECTION 11** (Scale 1/8" = 1'-0")  
 NOTE: SEE BEAM & JOINT LOCATION ARCH. DRAWINGS

D-7-60

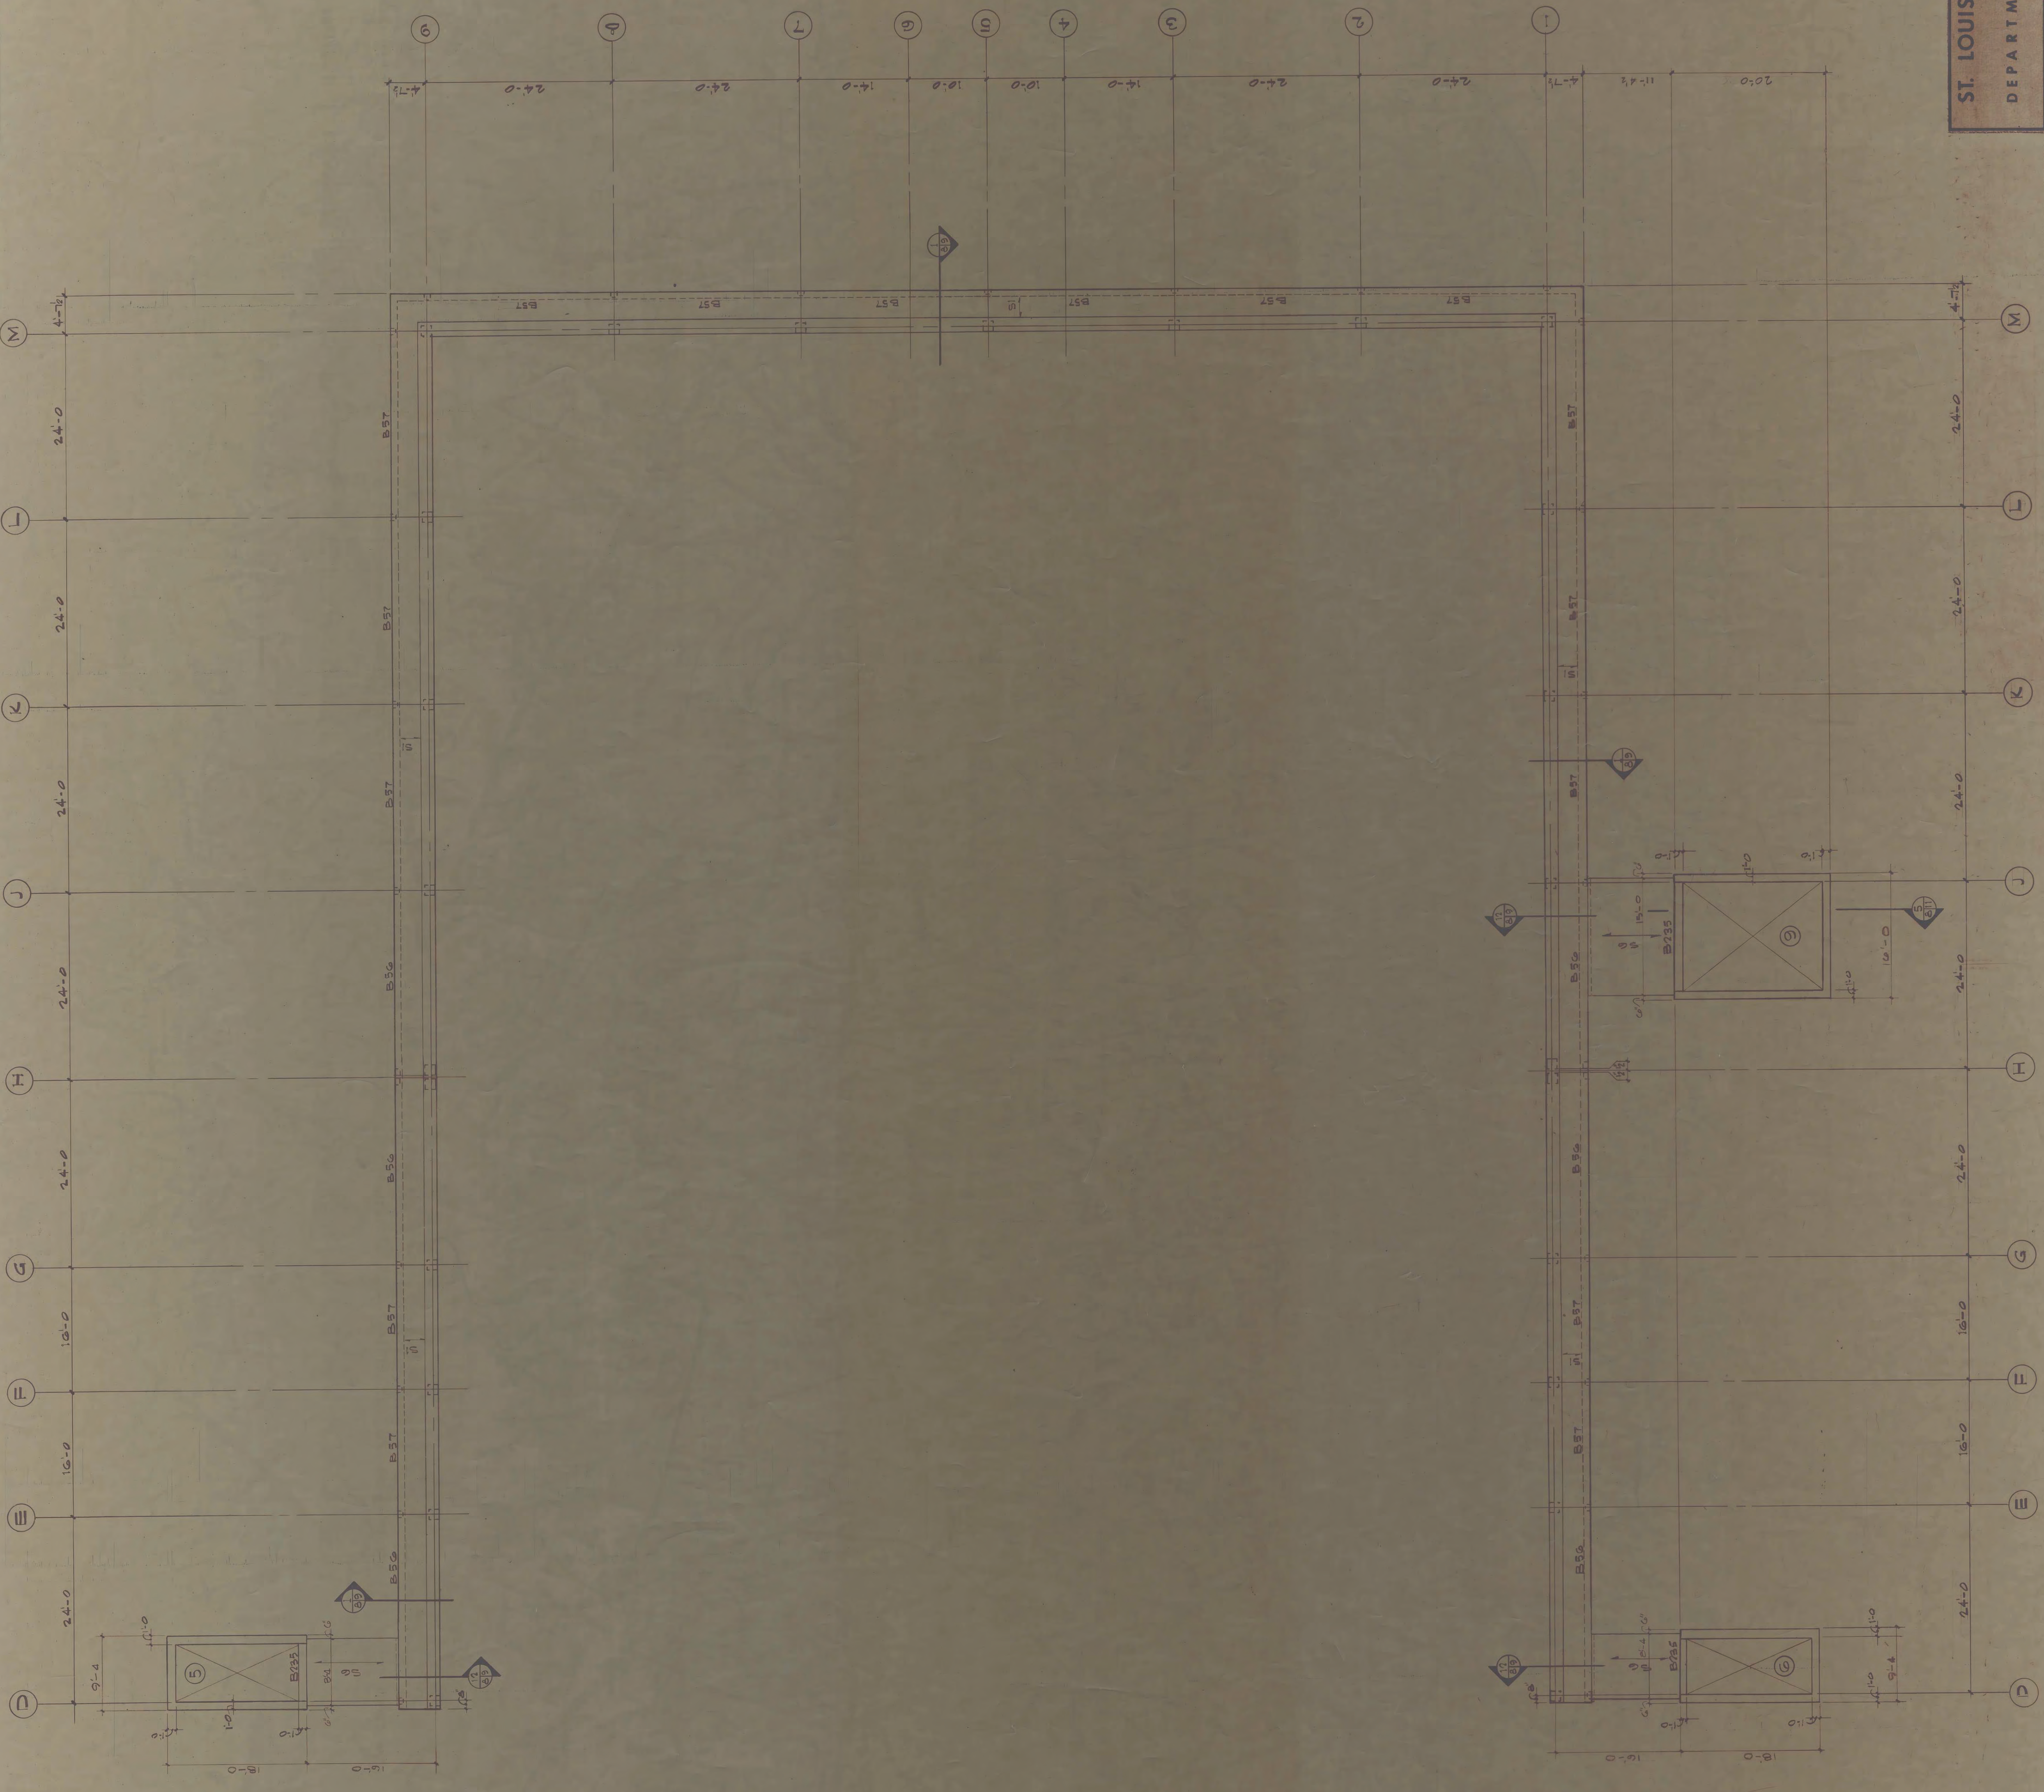

ST. LOUIS COUNTY JUVENILE CENTER FACILITY  
 CLAYTON MISSOURI  
 DEPARTMENT OF PUBLIC WORKS  
 DAVID E. MURRAY DIRECTOR



ARCHITECTS & ENGINEERS  
 PEARCE & PEARCE, INC.  
 CONSULTING ENGINEER  
 CASSIS ASSOCIATES, INC.  
 ROBERT F. BRUNS ELECTRICAL ENGINEER  
 CRAWFORD & WITTE, INC.  
 MECHANICAL ENGINEER

DRAWING NO. **S8**  
 PROJ. NO. 88012  
 DATE 10-1-60  
 DRAWN BY J. L. ...  
 CHECKED BY ...


LEVEL 3 ROOF FRAMING




LEVEL THREE ROOF FRAMING PLAN  
 SCALE 1/8"=1'-0"  
 TOP OF SLAB EL. 507'-4"

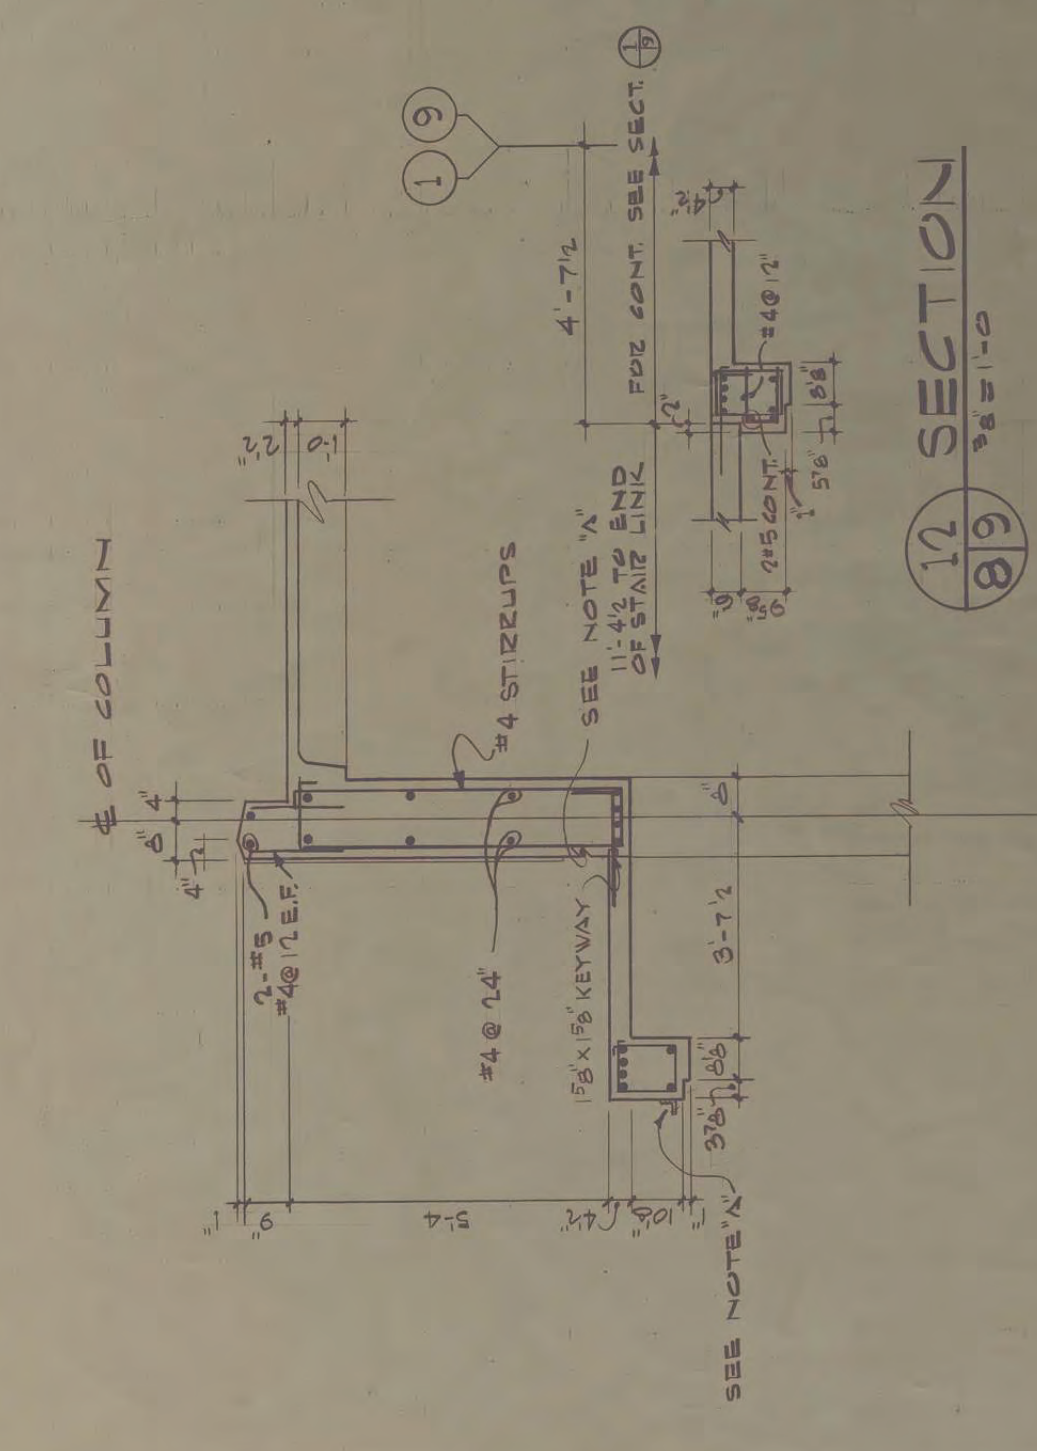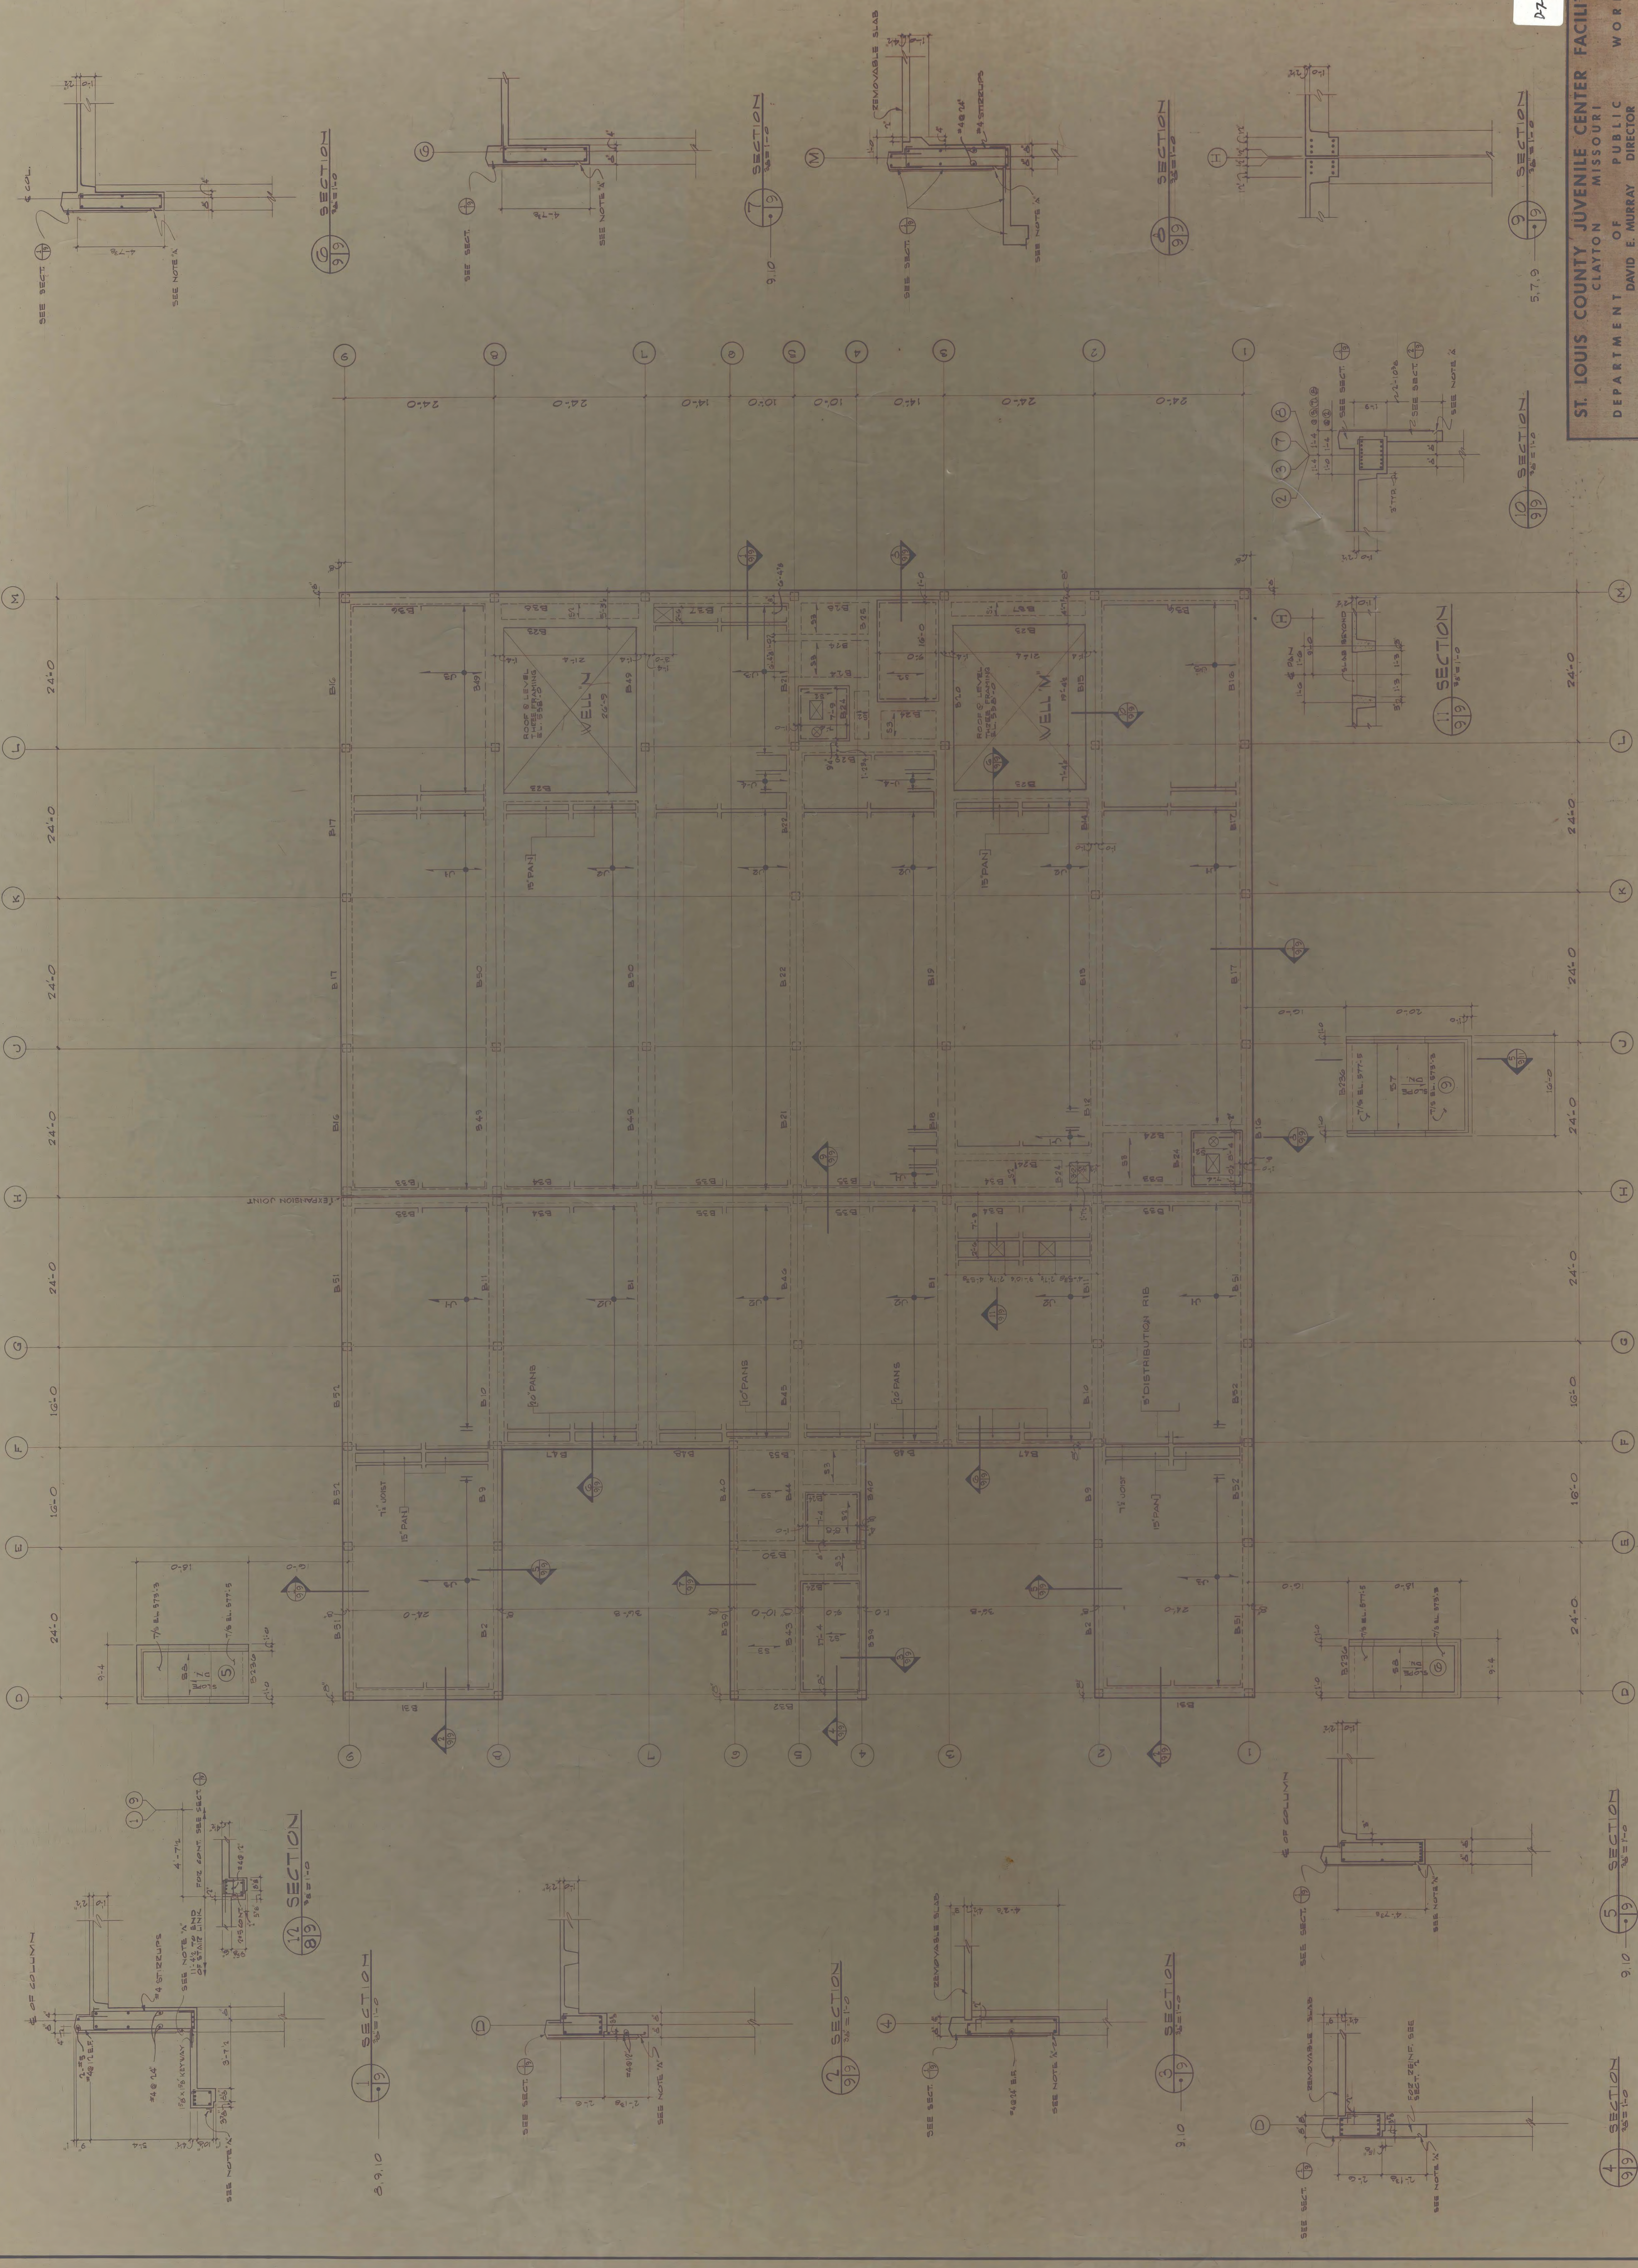


SECTION 1  
9.10

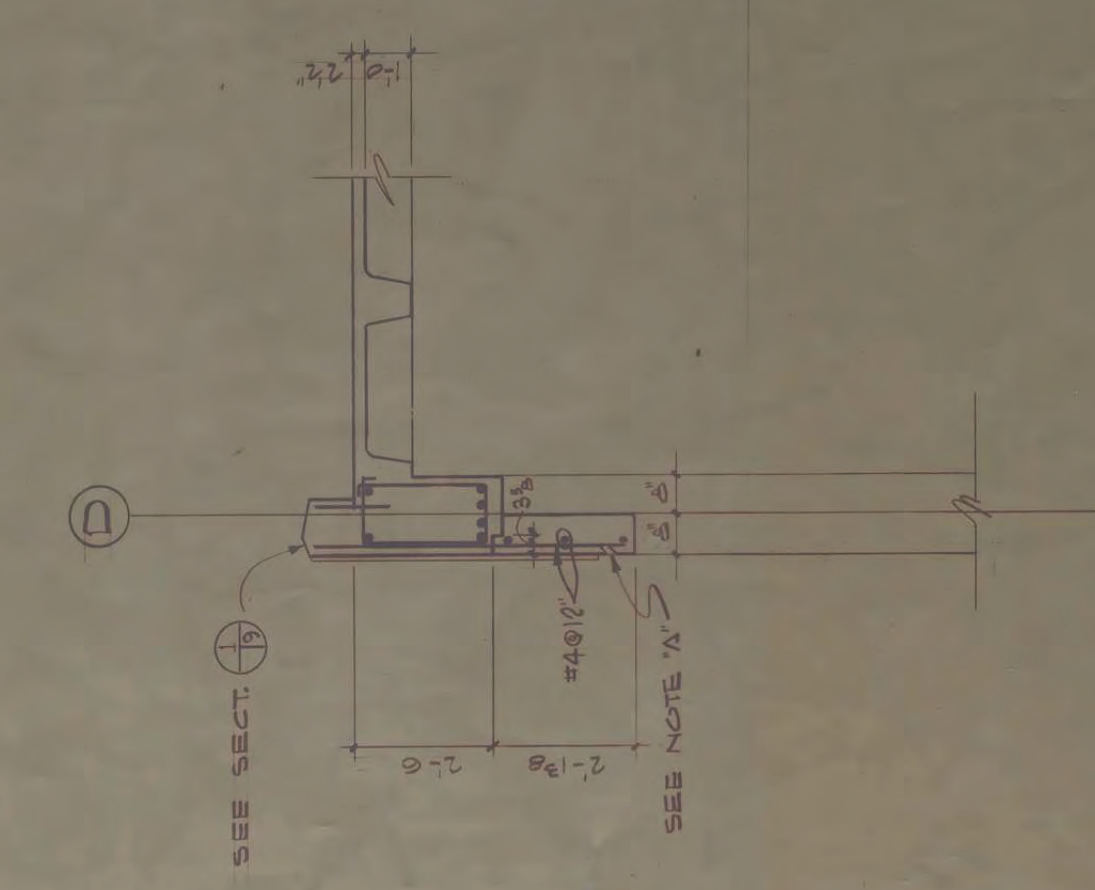

SECTION 2  
9.10

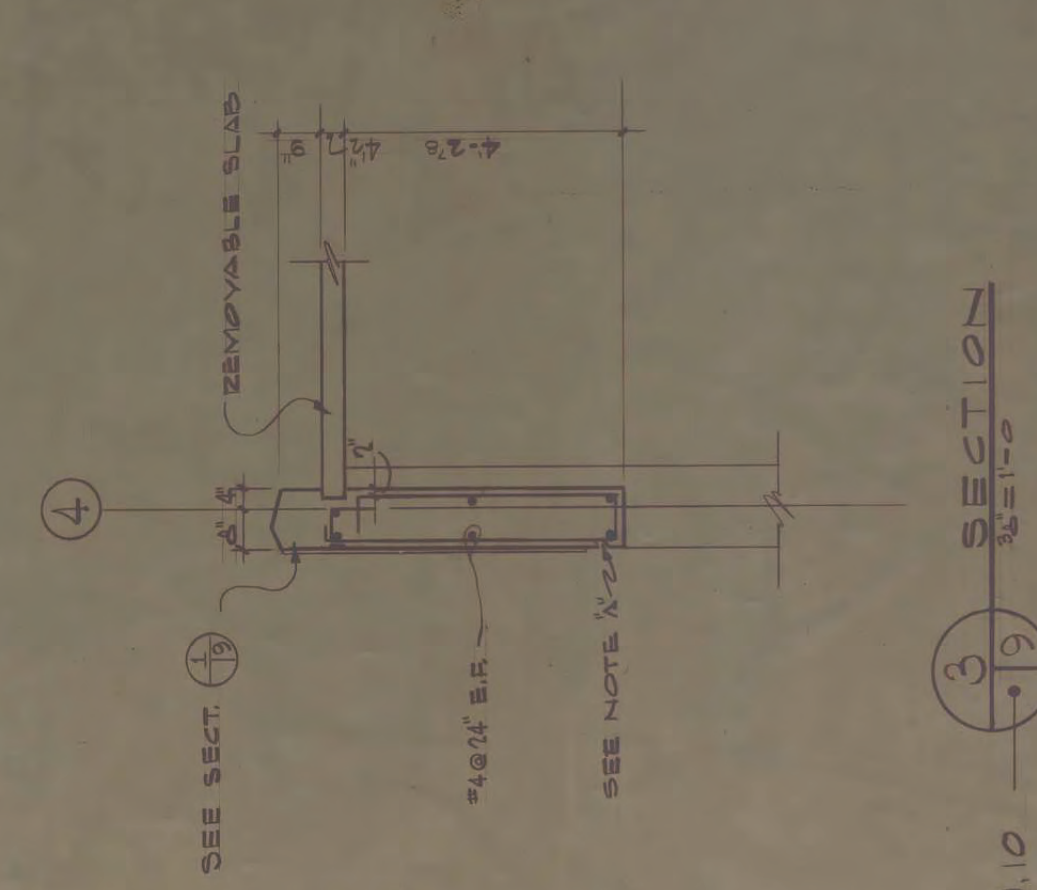

SECTION 3  
9.10

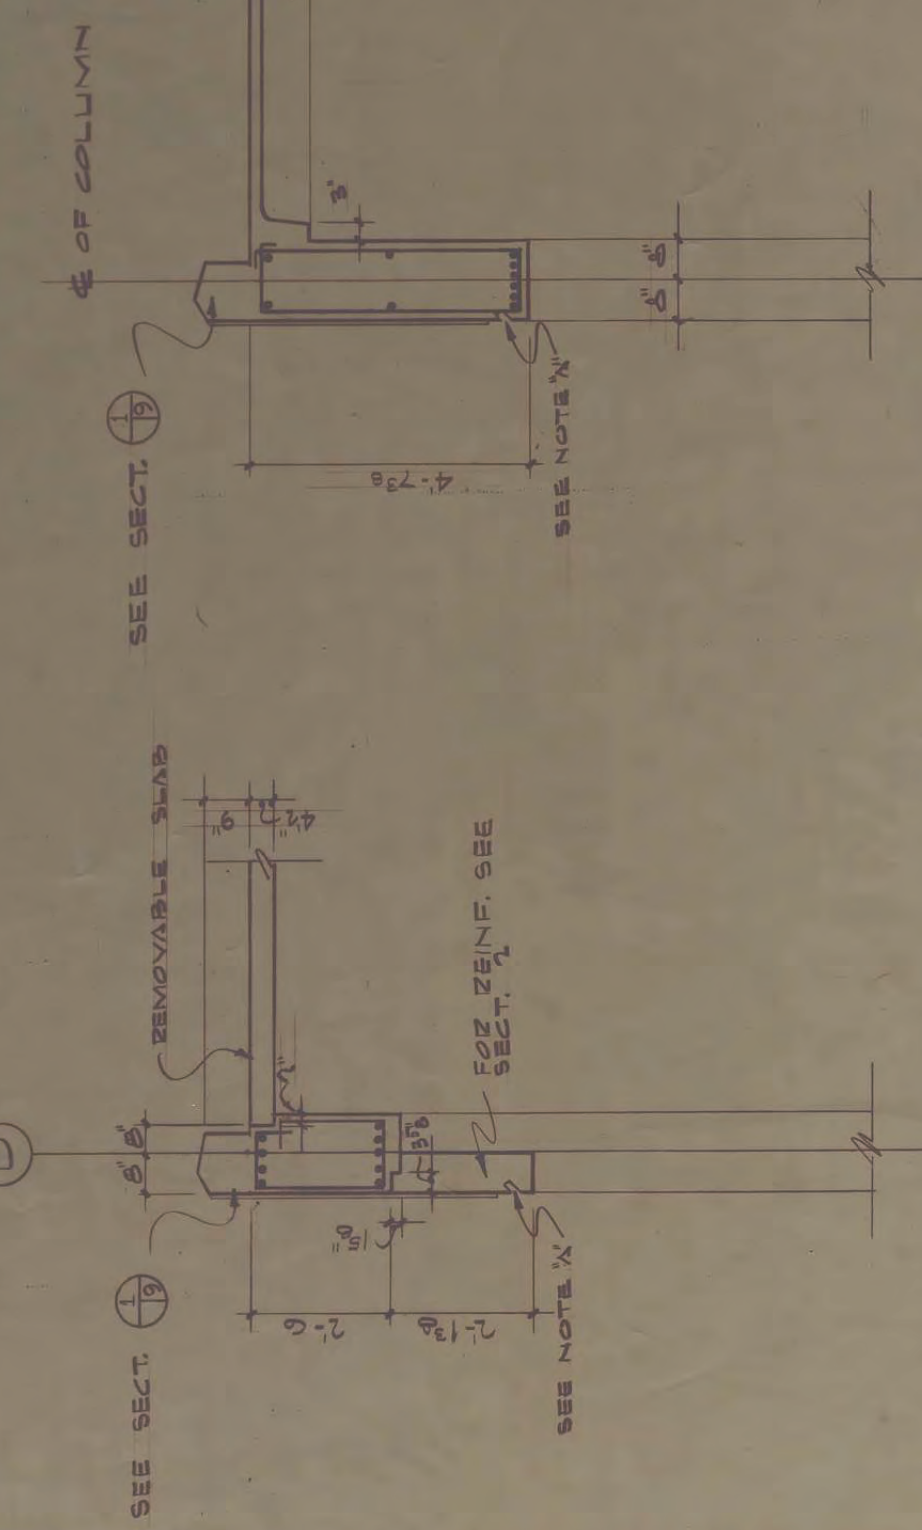

SECTION 4  
9.10

SECTION 5  
9.10

SECTION 9  
5.7.9

SECTION 10  
5.7.9

SECTION 11  
9.10

SECTION 12  
9.10

NOTE:  
 1. SEE ALL DIMENSIONS FOR CONSTRUCTION.  
 2. SEE ALL DIMENSIONS FOR CONSTRUCTION.

**ROOF FRAMING PLAN**  
 SCALE 1/8"=1'-0"  
 TOP OF SLAB EL. 572.45

**ST. LOUIS COUNTY JUVENILE CENTER FACILITY**  
 CLAYTON MISSOURI

DEPARTMENT OF PUBLIC WORKS  
 DIRECTOR: DAVID E. MURRAY

ARCHITECTS & ENGINEERS  
 PEARCE & PEARCE, INC.  
 CONSULTING ENGINEER  
 ROBERT F. BRUNS

ELECTRICAL ENGINEER  
 MECHANICAL ENGINEER  
 CRAWFORD & WITTE, INC.

DRAWING NO. **S9**  
 PROJECT NO. 8802  
 DATE 11/22/57  
 CHECKED BY JH